


COPYRIGHT:
 COPYRIGHT © 2018 EMCON PSE CONSULTANTS
 ALL RIGHTS RESERVED. NO PART OF THIS DRAWING MAY
 BE REPRODUCED STORED IN A RETRIEVAL SYSTEM OR
 TRANSMITTED IN ANY FORM OR BY ANY MEANS ELECTRONIC,
 ELECTROSTATIC, MAGNETIC TAPE, MECHANICAL, PHOTOCOPIING,
 RECORDING OR OTHERWISE, WITHOUT THE WRITTEN PERMISSION
 OF EMCON.

LEGEND:		QTY
	33kV LINE	
	22kV LINE	
	19.1kV SWER LINE	
	11kV OVERHEAD LINE	
	11kV LINE UNDERGROUND	
	400V ABC LINE	
	OVERHEAD SERVICE CABLE	
	UNDERGROUND SERVICE CABLE	
	TELEPHONE LINE	
	TRANSFORMER	
	LINKED FUSE (15A, TYPE K)	
	LOAD BREAK UNIT	
	STREET LIGHTS	
	LV POLE	
	MV POLE	
	KIOSK	
	FLY STAY STRUCTURE	
	STAY ASSEMBLY FOR 11kV LINE	
	STRUT ASSEMBLY FOR 11kV LINE	
	STAY ASSEMBLY FOR ABC LINE WITH WARNING PIPE	
	STRUT ASSEMBLY FOR ABC LINE	
	SLEEVES	
	8m KICK POLE FOR ARDAC	
	5m KICK POLE FOR ARDAC	
	KIOSK	
	DISTRIBUTION BOARD TYPE "A OR B" POLE MOUNTED	
	BRICK HOUSE	
	SINK HOUSE	
	WOOD HOUSE	

No.	REVISIONS	APP.	DATE

CLIENT:



NamPower

P.O BOX 2864
 Windhoek
 NAMIBIA

Tel: (061) 2054111
 Fax: (061) 232805

APPROVED BY CLIENT _____ DATE _____
 COPYRIGHT RESERVED

EMCON PSE CONSULTANTS



POWER PLANNING UNIT

Box 1900 4 Bassingthwaigite Street Tel: (061) 224725
 Windhoek Klein Windhoek Fax: (061) 233207
 NAMIBIA E-mail: emcon@emcongroup.com

PROJECT


NAMPOWER 2018 RURAL ELECTRIFICATION
 OMUSATI REGION

DRAWING TITLE

ELECTRICAL KEYMAP FOR
 AKATI PS
 S: -17.401236
 E: 14.755319


DESIGNED:W.A	DRAWN:W.A	CHECKED:H.H	SCALE:N.T.S
CONSULTANT PROJ. No:PP 237A			DATE:NOV 2018
DRAWING No: PSE/2018/00/EE1-01			REV: 00

AKATI PS

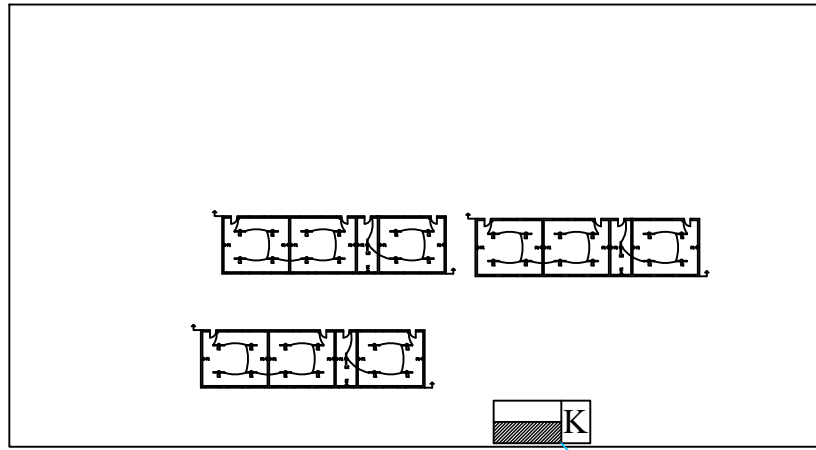

25mm²x4C

Akati TRF
50 kVA
S 17.40099
E 14.75542

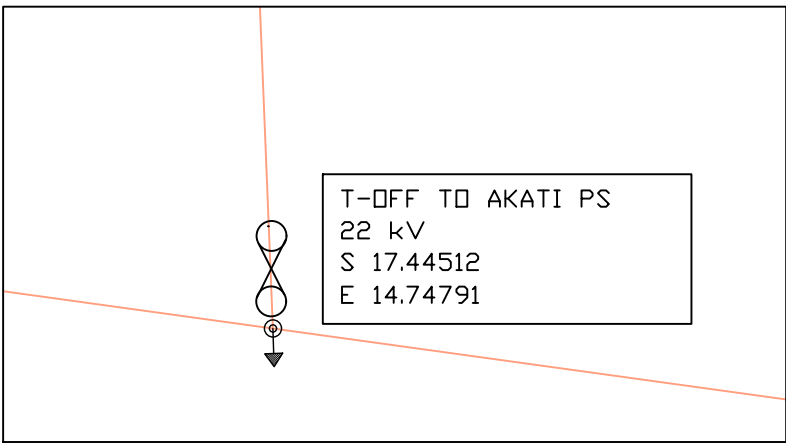


T-OFF TO AKATI PS
22 kV
S 17.44512
E 14.74791

COPYRIGHT: © 2018 EMCON PSE CONSULTANTS
ALL RIGHTS RESERVED. NO PART OF THIS DRAWING MAY BE REPRODUCED STORED IN A RETRIEVAL SYSTEM OR TRANSMITTED IN ANY FORM OR BY ANY MEANS ELECTRONIC, ELECTROSTATIC, MAGNETIC TAPE, MECHANICAL, PHOTOCOPIING, RECORDING OR OTHERWISE, WITHOUT THE WRITTEN PERMISSION OF EMCON.

LEGEND:		QTY
	33kV LINE	
	22kV LINE	
	19.1kV SWER LINE	
	11kV OVERHEAD LINE	
	11kV LINE UNDERGROUND	
	400V ABC LINE	
	OVERHEAD SERVICE CABLE	
	UNDERGROUND SERVICE CABLE	
	TELEPHONE LINE	
	TRANSFORMER	
	LINKED FUSE (15A, TYPE K)	
	LOAD BREAK UNIT	
	STREET LIGHTS	
	LV POLE	
	MV POLE	
	KIOSK	
	FLY STAY STRUCTURE	
	STAY ASSEMBLY FOR 11kV LINE	
	STAY ASSEMBLY FOR 11kV LINE	
	STAY ASSEMBLY FOR ABC LINE WITH WARNING PIPE	
	STAY ASSEMBLY FOR ABC LINE	
	SLEEVES	
	8m KICK POLE FOR ARDAC	
	5m KICK POLE FOR ARDAC	
	KIOSK	
	DISTRIBUTION BOARD TYPE "A OR B" POLE MOUNTED	
	BRICK HOUSE	
	SINK HOUSE	
	WOOD HOUSE	

No.	REVISIONS	APP.	DATE

CLIENT:

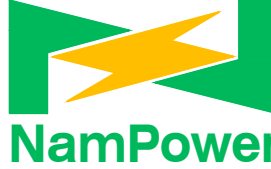

NamPower

P.O BOX 2864
Windhoek
NAMIBIA

Tel: (061) 2054111
Fax: (061) 232805

APPROVED BY CLIENT _____ DATE _____
COPYRIGHT RESERVED

EMCON PSE CONSULTANTS



POWER PLANNING UNIT

Box 1900 4 Bassingthwaighe Street Tel: (061) 224725
Windhoek Klein Windhoek Fax: (061) 233207
NAMIBIA E-mail: emcon@emcongroup.com

PROJECT

NAMPOWER 2018 RURAL ELECTRIFICATION
OMUSATI REGION

DRAWING TITLE

ELECTRICAL MV AND LV LAYOUT FOR
AKATI PS
S: -17.401236
E: 14.755319


DESIGNED:W.A	DRAWN:W.A	CHECKED:H.H	SCALE:N.T.S
CONSULTANT PROJ. No:PP 137A			DATE: Nov 2018
DRAWING No: PSE/2018/00/EE1-02			REV:00

COPYRIGHT: © 2018 EMCON PSE CONSULTANTS
 ALL RIGHTS RESERVED. NO PART OF THIS DRAWING MAY BE REPRODUCED STORED IN A RETRIEVAL SYSTEM OR TRANSMITTED IN ANY FORM OR BY ANY MEANS ELECTRONIC, ELECTROSTATIC, MAGNETIC TAPE, MECHANICAL, PHOTOCOPIING, RECORDING OR OTHERWISE, WITHOUT THE WRITTEN PERMISSION OF EMCON.

LEGEND:		QTY
	33kV LINE	
	22kV LINE	
	19.1kV SWER LINE	
	11kV OVERHEAD LINE	
	11kV LINE UNDERGROUND	
	400V ABC LINE	
	OVERHEAD SERVICE CABLE	
	UNDERGROUND SERVICE CABLE	
	TELEPHONE LINE	
	TRANSFORMER	
	LINKED FUSE (15A, TYPE K)	
	LOAD BREAK UNIT	
	STREET LIGHTS	
	LV POLE	
	MV POLE	
	KIOSK	
	FLY STAY STRUCTURE	
	STRUT ASSEMBLY FOR 11kV LINE	
	STRUT ASSEMBLY FOR 11kV LINE	
	STRUT ASSEMBLY FOR ABC LINE WITH WARNING PIPE	
	STRUT ASSEMBLY FOR ABC LINE	
	SLEEVES	
	8m KICK POLE FOR ARDAC	
	5m KICK POLE FOR ARDAC	
	KIOSK	
	DISTRIBUTION BOARD TYPE "A OR B" POLE MOUNTED	
	BRICK HOUSE	
	SINK HOUSE	
	WOOD HOUSE	

No.	REVISIONS	APP.	DATE

CLIENT:

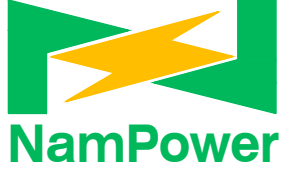


NamPower

P.O BOX 2864 Windhoek NAMIBIA
 Tel: (061) 2054111 Fax: (061) 232805

APPROVED BY CLIENT _____ DATE _____
 COPYRIGHT RESERVED

EMCON PSE CONSULTANTS



POWER PLANNING UNIT

Box 1900 Windhoek NAMIBIA
 4 Bassingthwaigite Street Klein Windhoek
 Tel: (061) 224725 Fax: (061) 233207
 E-mail: emcon@emcongroup.com


PROJECT

NAMPOWER 2018 RURAL ELECTRIFICATION
 OMUSATI REGION

DRAWING TITLE

ELECTRICAL LAYOUT FOR
 AKATI PS
 S: -17.401236
 E: 14.755319

DESIGNED: w.a	DRAWN: w.a	CHECKED: w.a	SCALE: N.T.S
CONSULTANT PROJ. No: PP 237A			DATE: NOV 2019
DRAWING No: PSE/237A/01/SW-01			REV: 00

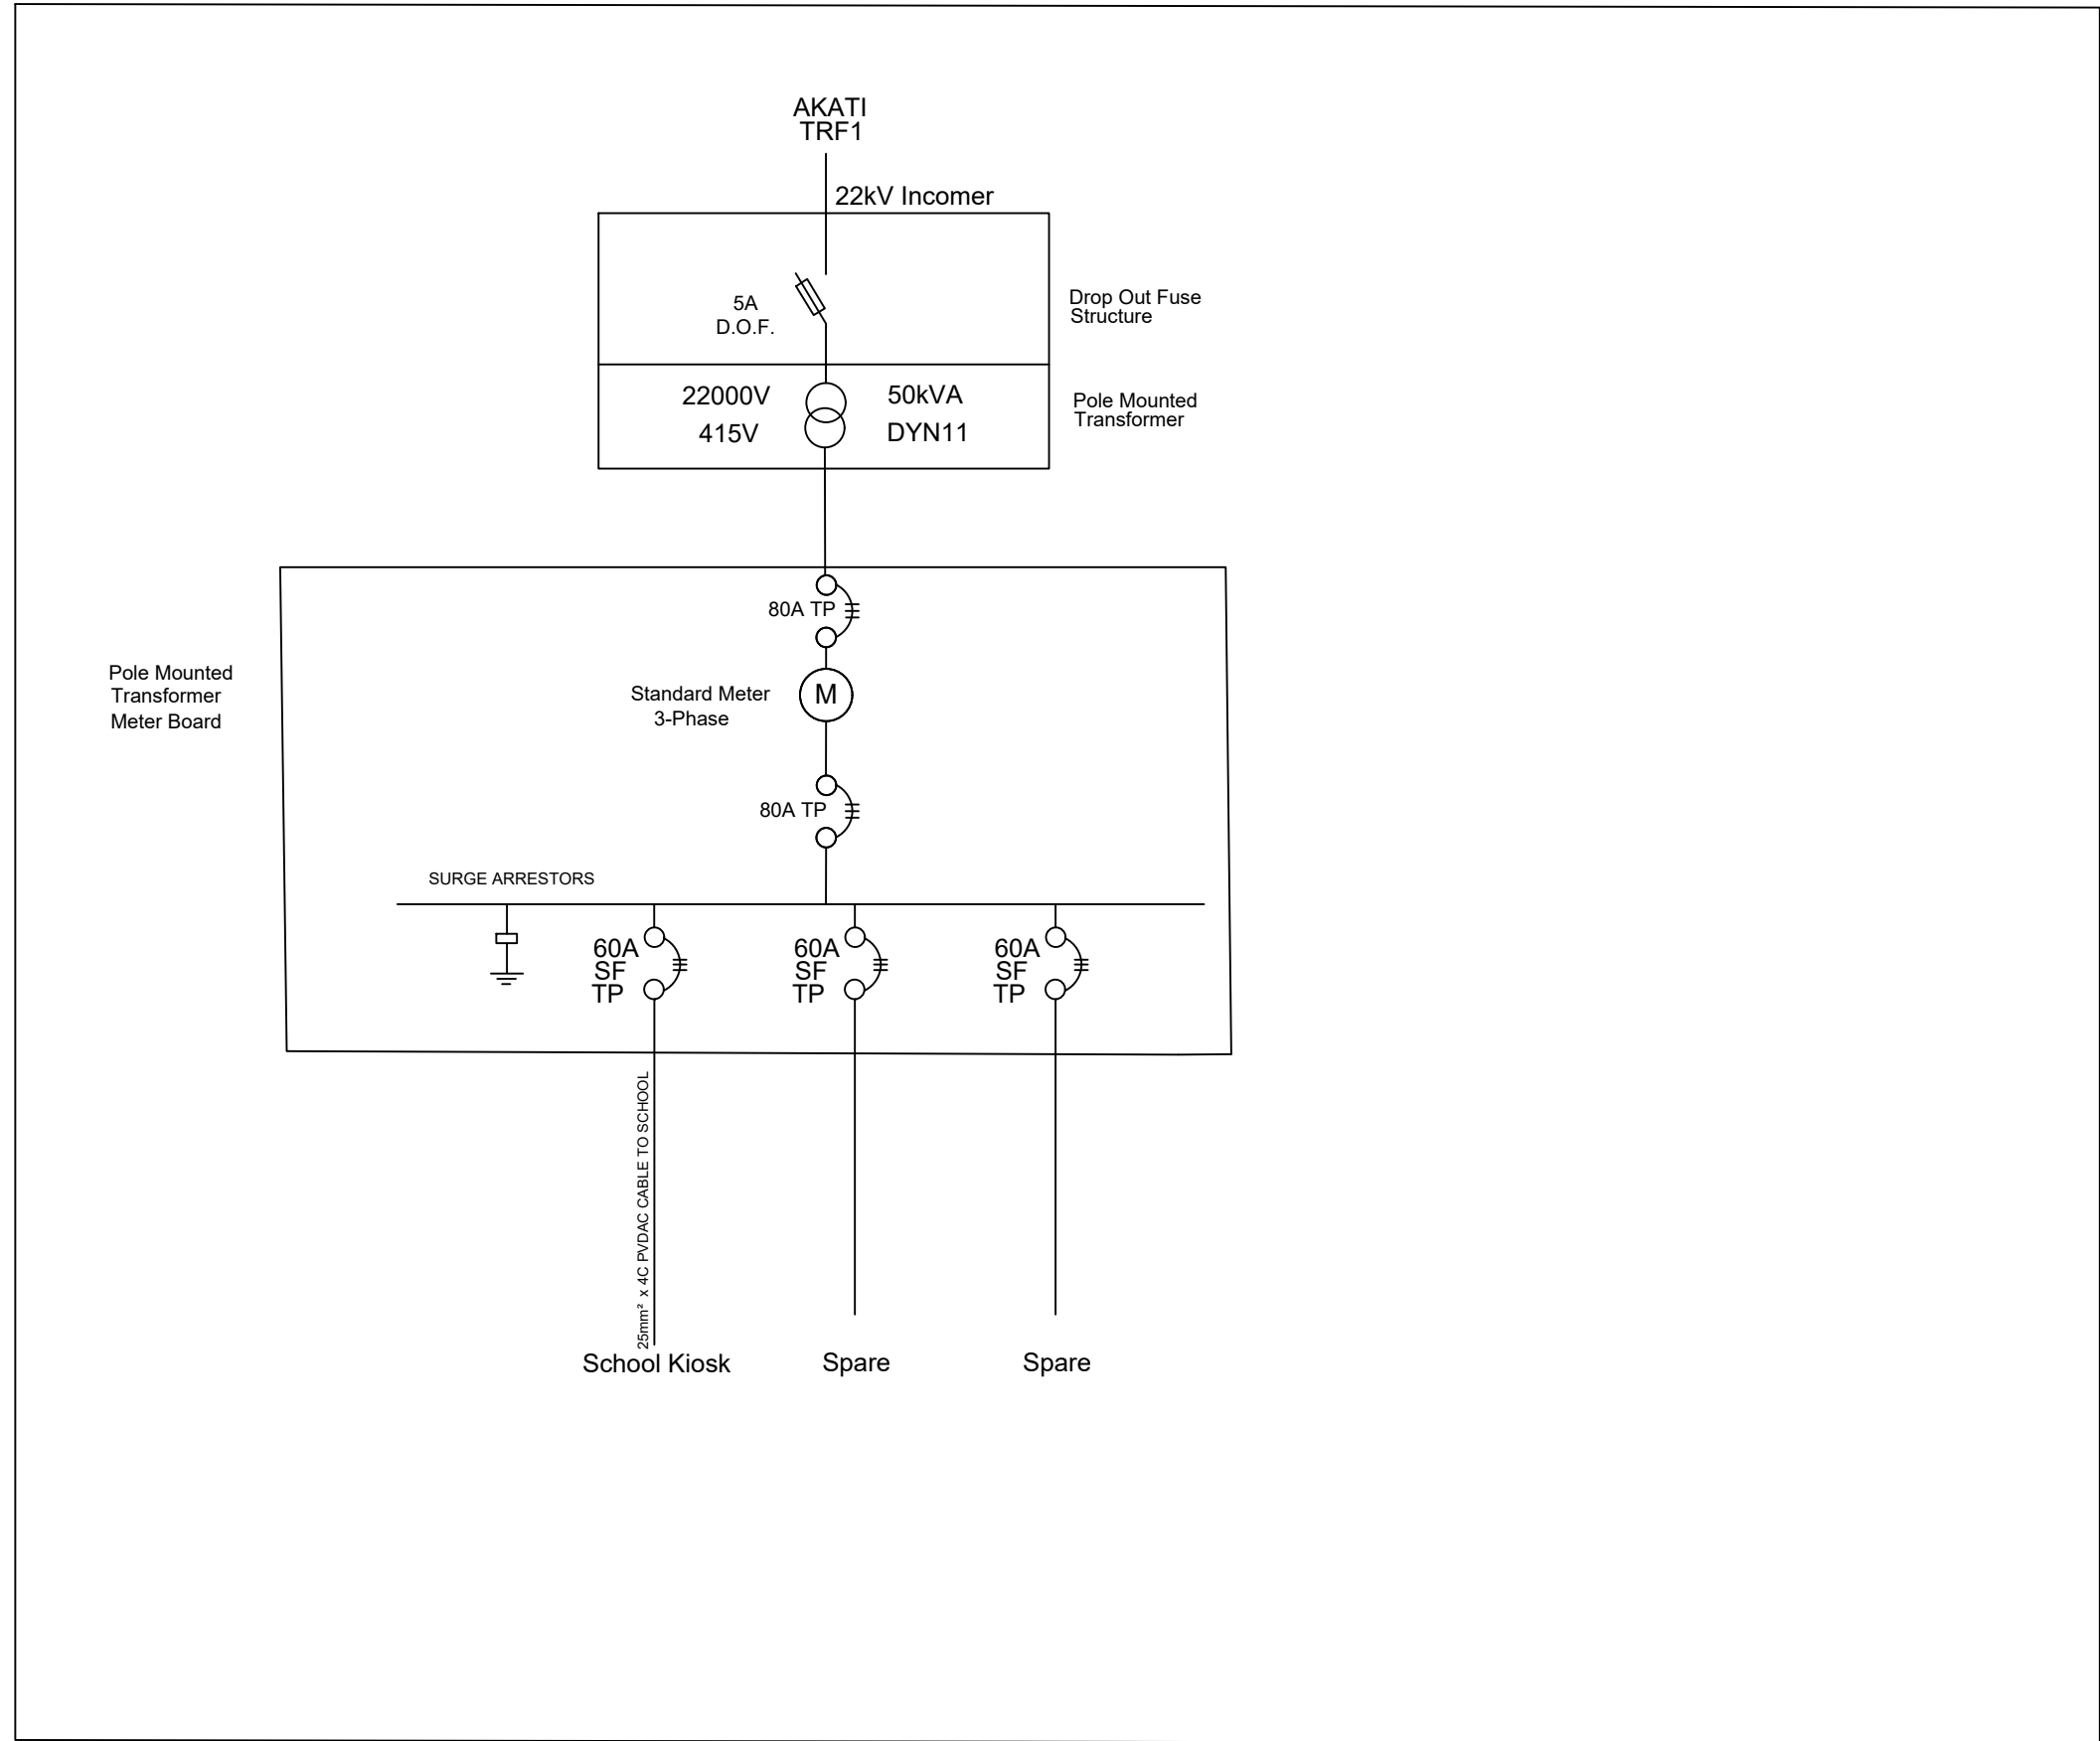

Pole Mounted Transformer Meter Board

School Kiosk Spare Spare




COPYRIGHT:
 COPYRIGHT © 2016 EMCON TURNKEY SOLUTIONS
 ALL RIGHTS RESERVED. NO PART OF THIS DRAWING MAY BE REPRODUCED, STORED IN A RETRIEVAL SYSTEM OR TRANSMITTED IN ANY FORM OR BY ANY MEANS ELECTRONIC, ELECTROSTATIC, MAGNETIC TAPE, MECHANICAL, PHOTOCOPIING, RECORDING OR OTHERWISE, WITHOUT THE WRITTEN PERMISSION OF EMCON.

LEGEND:

Symbol/Color	Description	QTY
— (Pink)	33kV LINE	
— (Blue)	22kV LINE	
— (Blue)	19.1kV SWER LINE	
— (Red)	11kV OVERHEAD LINE	
— (Red)	11kV LINE UNDERGROUND	
— (Green)	400V ABC LINE	
— (Blue)	OVERHEAD SERVICE CABLE	
— (Blue)	UNDERGROUND SERVICE CABLE	
— (Black)	TELEPHONE LINE	
⊗	TRANSFORMER	
⊙	LINKED FUSE (15A, TYPE K)	
⊞	LOAD BREAK UNIT	
⊖	STREET LIGHTS	
○	LV POLE	
⊙	MV POLE	
⊞	KIOSK	
FS	FLY STAY STRUCTURE	
⊙	STAY ASSEMBLY FOR 11kV LINE	
⊙	STRUT ASSEMBLY FOR 11kV LINE	
⊙	STAY ASSEMBLY FOR ABC LINE WITH WARNING PIPE	
⊙	STRUT ASSEMBLY FOR ABC LINE	
—	SLEEVES	
⊙	8m KICK POLE FOR AIRDAC	
⊙	5m KICK POLE FOR AIRDAC	
⊞	KIOSK	
⊞	DISTRIBUTION BOARD TYPE "A OR B" POLE MOUNTED	
B	BRICK HOUSE	
Z	SINK HOUSE	
W	WOOD HOUSE	

No.	REVISIONS	APP.	DATE

CLIENT:



NamPower

P.O BOX 2864
Windhoek
NAMIBIA

Tel: (061) 2054111
Fax: (061) 232805

APPROVED BY CLIENT _____ DATE _____
 COPYRIGHT RESERVED

EMCON TURNKEY SOLUTIONS



POWER PLANNING UNIT

Box 1900 4 Bossingthwaighe Street Tel: (061) 224725
 Windhoek Klein Windhoek Fax: (061) 233207
 NAMIBIA E-mail: emcon@emcongroup.com

PROJECT


NAMPOWER 2018 RURAL ELECTRIFICATION
 OMUSATI REGION

DRAWING TITLE

ELECTRICAL KEYMAP FOR
 OMALAGO PS
 S: -17.87502581
 E: 14.91645416

DESIGNED:P.H	DRAWN:P.H	CHECKED:H.H	SCALE:N.T.S
CONSULTANT PROJ. No:PP 237B			DATE:JUN 2018
DRAWING No: PSE/2018/00/EE1-01			REV: 00

AS-BUILT

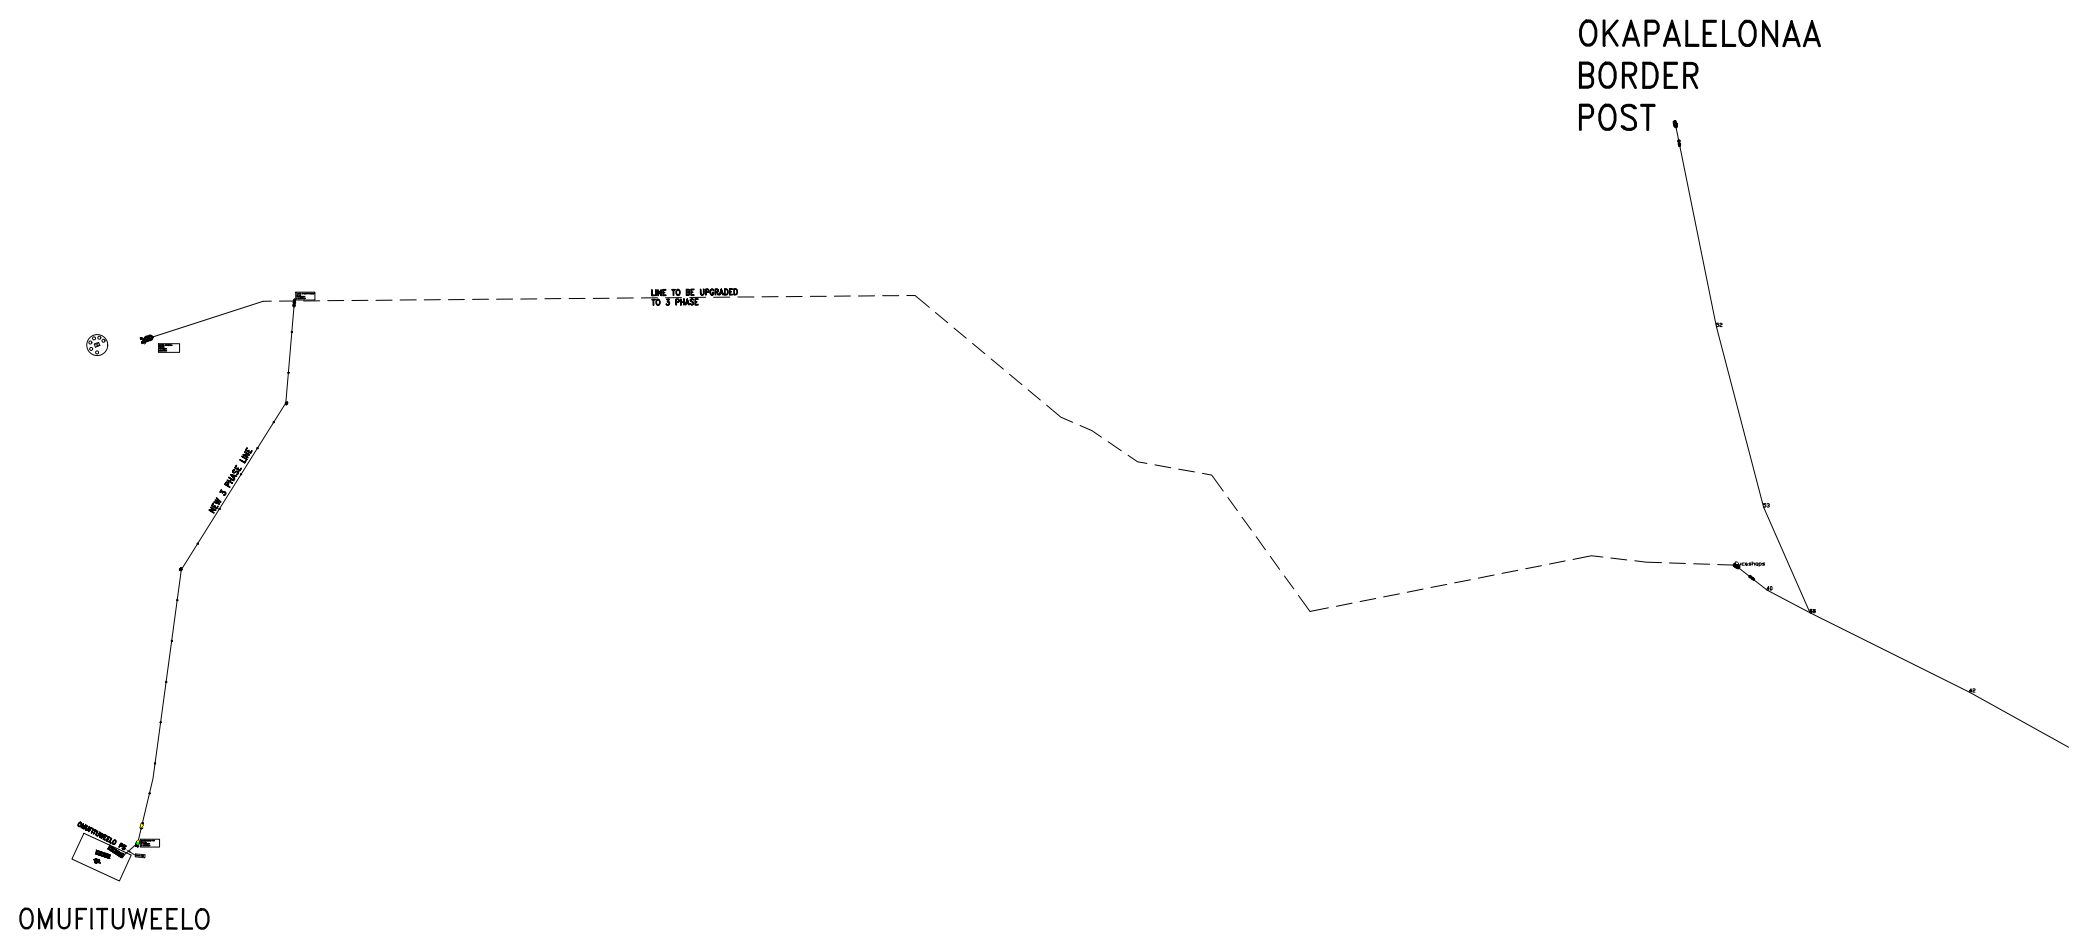


COPYRIGHT:
 COPYRIGHT © 2019 EMCON PSE CONSULTING
 ALL RIGHTS RESERVED. NO PART OF THIS DRAWING MAY BE REPRODUCED STORED IN A RETRIEVAL SYSTEM OR TRANSMITTED IN ANY FORM OR BY ANY MEANS ELECTRONIC, ELECTROSTATIC, MAGNETIC TAPE, MECHANICAL, PHOTOCOPIING, RECORDING OR OTHERWISE, WITHOUT THE WRITTEN PERMISSION OF EMCON.

LEGEND:		QTY
---	33kV LINE	
---	22kV LINE	
---	19.1kV SWER LINE	
---	11kV OVERHEAD LINE	
---	11kV LINE UNDERGROUND	
---	400V ABC LINE	
---	OVERHEAD SERVICE CABLE	
---	UNDERGROUND SERVICE CABLE	
---	TELEPHONE LINE	
⊗	TRANSFORMER	
⊙	LINKED FUSE (15A, TYPE K)	
⊕	LOAD BREAK UNIT	
⊙	STREET LIGHTS	
○	LV POLE	
⊙	MV POLE	
⊕	KIOSK	
FS	FLY STAY STRUCTURE	
⊕→	STAY ASSEMBLY FOR 11kV LINE	
→⊕	STAY ASSEMBLY FOR 11kV LINE	
⊕→	STAY ASSEMBLY FOR ABC LINE WITH WARNING PIPE	
→⊕	STAY ASSEMBLY FOR ABC LINE	
---	SLEEVES	
●	8m KICK POLE FOR ARDAC	
●	5m KICK POLE FOR ARDAC	
⊕	KIOSK	
⊕	DISTRIBUTION BOARD TYPE "A OR B" POLE MOUNTED	
B	BRICK HOUSE	
Z	SINK HOUSE	
W	WOOD HOUSE	

No.	REVISIONS	APP.	DATE

CLIENT:



NamPower

P.O BOX 2864
 Windhoek
 NAMIBIA

Tel: (061) 2054111
 Fax: (061) 232805

APPROVED BY CLIENT _____ DATE _____
 COPYRIGHT RESERVED

EMCON PSE CONSULTING



POWER PLANNING UNIT

Box 1900 4 Bassingthwaigite Street Tel: (061) 224725
 Windhoek Klein Windhoek Fax: (061) 233207
 NAMIBIA E-mail: emcon@emcogroup.com

PROJECT



NAMPOWER 2019 RURAL ELECTRIFICATION
 OMUSATI REGION

DRAWING TITLE

ELECTRICAL KEYMAP FOR
 OMUFITUWEELO PS
 S: -17.414922
 E: 14.932926

DESIGNED:W.A	DRAWN:W.A	CHECKED:H.H	SCALE:N.T.S
CONSULTANT PROJ. No:PP 237C			DATE:JUNE 2019
DRAWING No: PSE/EE1-01			REV: 1

AS-BUILT

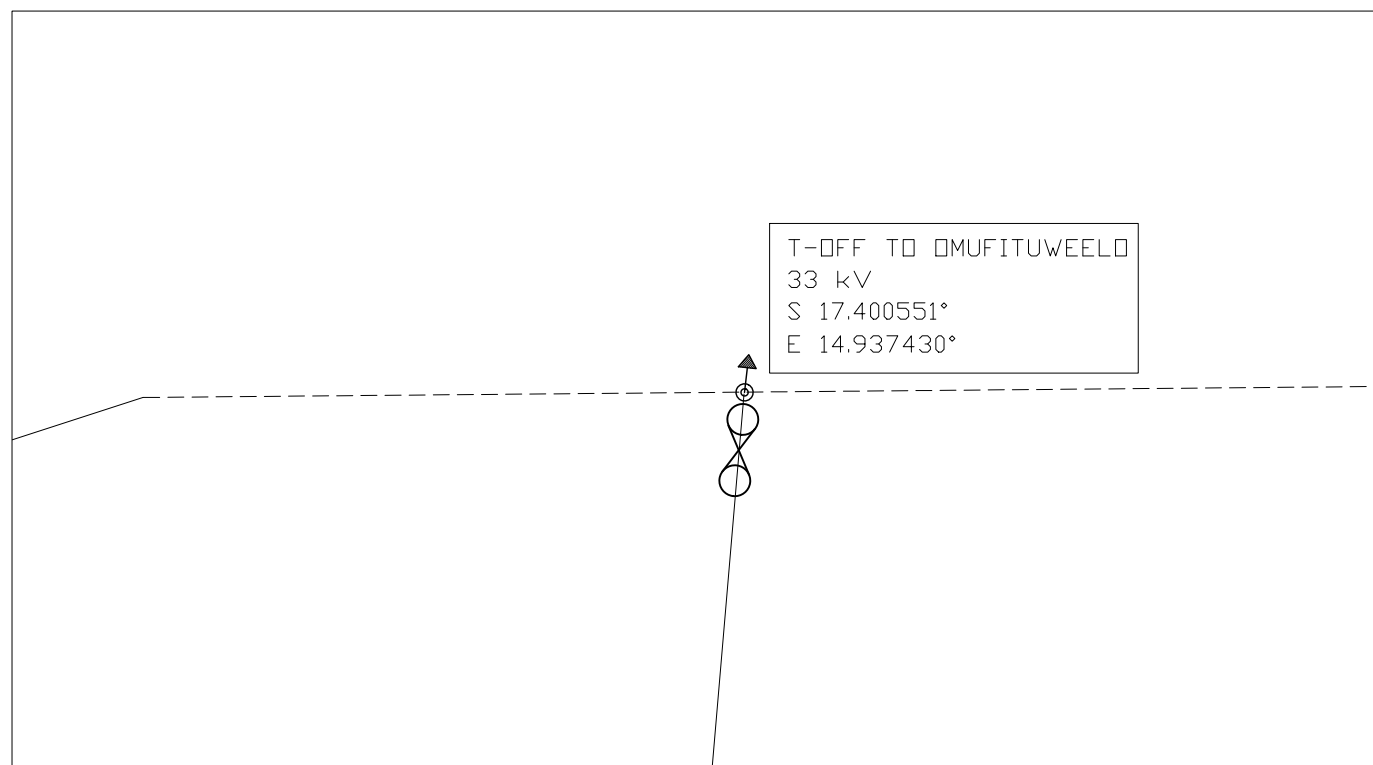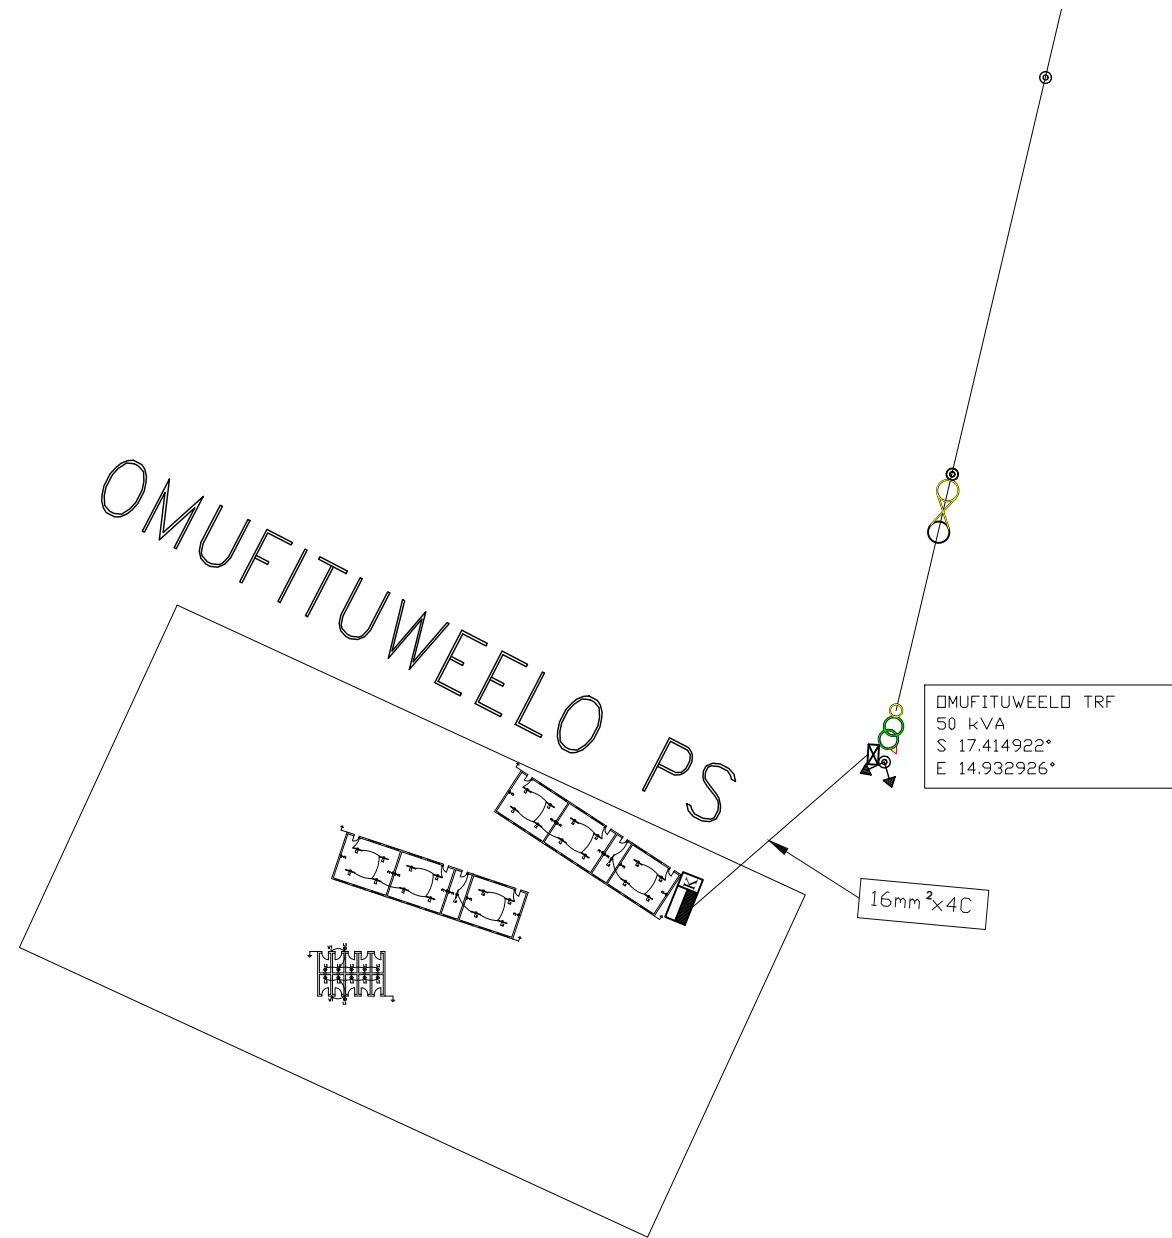


COPYRIGHT:
 COPYRIGHT © 2019 EMCON PSE CONSULTING
 ALL RIGHTS RESERVED. NO PART OF THIS DRAWING MAY
 BE REPRODUCED STORED IN A RETRIEVAL SYSTEM OR
 TRANSMITTED IN ANY FORM OR BY ANY MEANS ELECTRONIC,
 ELECTROSTATIC, MAGNETIC TAPE, MECHANICAL, PHOTOCOPIING,
 RECORDING OR OTHERWISE, WITHOUT THE WRITTEN PERMISSION
 OF EMCON.

LEGEND:		QTY
---	33kV LINE	
---	22kV LINE	
---	19.1kV SWER LINE	
---	11kV OVERHEAD LINE	
---	11kV LINE UNDERGROUND	
---	400V ABC LINE	
---	OVERHEAD SERVICE CABLE	
---	UNDERGROUND SERVICE CABLE	
---	TELEPHONE LINE	
⊗	TRANSFORMER	
⊙	LINKED FUSE (15A, TYPE K)	
⊕	LOAD BREAK UNIT	
⊖	STREET LIGHTS	
○	LV POLE	
⊙	MV POLE	
⊠	KIOSK	
FS	FLY STAY STRUCTURE	
⊕→	STAY ASSEMBLY FOR 11kV LINE	
→⊕	STAY ASSEMBLY FOR 11kV LINE	
⊕→	STAY ASSEMBLY FOR ABC LINE WITH WARNING PIPE	
→⊕	STAY ASSEMBLY FOR ABC LINE	
---	SLEEVES	
●	8m KICK POLE FOR AIRDAC	
●	5m KICK POLE FOR AIRDAC	
⊠	KIOSK	
⊠	DISTRIBUTION BOARD TYPE "A OR B" POLE MOUNTED	
B	BRICK HOUSE	
Z	SINK HOUSE	
W	WOOD HOUSE	

No.	REVISIONS	APP.	DATE

CLIENT:

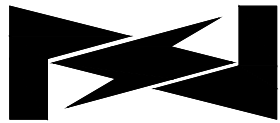

NamPower

P.O BOX 2864
 Windhoek
 NAMIBIA

Tel: (061) 2054111
 Fax: (061) 232805

APPROVED BY CLIENT _____ DATE _____
 COPYRIGHT RESERVED

EMCON PSE CONSULTING



POWER PLANNING UNIT

Box 1900 4 Bassingthwaigite Street Tel: (061) 224725
 Windhoek Klein Windhoek Fax: (061) 233207
 NAMIBIA E-mail: emcon@emcongroup.com

PROJECT

NAMPOWER 2019 RURAL ELECTRIFICATION
 OMUSATI REGION

DRAWING TITLE

ELECTRICAL KEYMAP FOR
 OMUFITUWEELO PS
 S: -17.414922
 E: 14.932926

DESIGNED:W.A	DRAWN:W.A	CHECKED:H.H	SCALE:N.T.S
CONSULTANT PROJ. No:PP 237C			DATE: JUNE 2019
DRAWING No: PSE/EE1-02			REV: 1


AS-BUILT

COPYRIGHT:
 COPYRIGHT © 2019 EMCON PSE CONSULTING
 ALL RIGHTS RESERVED. NO PART OF THIS DRAWING MAY
 BE REPRODUCED STORED IN A RETRIEVAL SYSTEM OR
 TRANSMITTED IN ANY FORM OR BY ANY MEANS ELECTRONIC,
 ELECTROSTATIC, MAGNETIC TAPE, MECHANICAL, PHOTOCOPIING,
 RECORDING OR OTHERWISE, WITHOUT THE WRITTEN PERMISSION
 OF EMCON.

LEGEND:	QTY	
---	33KV LINE	
---	22KV LINE	
---	19.1KV SWER LINE	
---	11KV OVERHEAD LINE	
---	11KV LINE UNDERGROUND	
---	400V ABC LINE	
---	OVERHEAD SERVICE CABLE	
---	UNDERGROUND SERVICE CABLE	
---	TELEPHONE LINE	
⊗	TRANSFORMER	
○-○	LINKED FUSE (15A, TYPE K)	
⊕	LOAD BREAK UNIT	
⊖	STREET LIGHTS	
○	LV POLE	
⊙	MV POLE	
⊠	KIOSK	
FS	FLY STAY STRUCTURE	
⊕→	STAY ASSEMBLY FOR 11KV LINE	
→⊕	STAY ASSEMBLY FOR 11KV LINE	
⊕→	STAY ASSEMBLY FOR ABC LINE WITH WARNING PIPE	
→⊕	STAY ASSEMBLY FOR ABC LINE	
---	SLEEVES	
●	8m KICK POLE FOR ARDAC	
⊙	5m KICK POLE FOR ARDAC	
⊠	KIOSK	
⊠	DISTRIBUTION BOARD TYPE "A OR B" POLE MOUNTED	
B	BRICK HOUSE	
Z	SINK HOUSE	
W	WOOD HOUSE	

No.	REVISIONS	APP.	DATE

CLIENT:

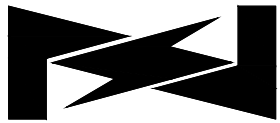

NamPower

P.O BOX 2864 Windhoek NAMIBIA
 Tel: (061) 2054111 Fax: (061) 232805

APPROVED BY CLIENT _____ DATE _____
 COPYRIGHT RESERVED

EMCON PSE CONSULTING




POWER PLANNING UNIT

Box 1900 Windhoek NAMIBIA
 4 Bassingthwaigthe Street Klein Windhoek
 Tel: (061) 224725 Fax: (061) 233207
 E-mail: emcon@emcongroup.com

PROJECT
 NAMPOWER 2019 RURAL ELECTRIFICATION
 OMUSATI REGION

DRAWING TITLE
 ELECTRICAL SINGLE
 LINE DIAGRAM FOR
 OMUFITUWEELO PS
 S: -17.414922
 E: 14.932926



DESIGNED:W.A	DRAWN:W.A	CHECKED:H.H	SCALE:N.T.S
CONSULTANT PROJ. No: PP 237C			DATE:JUNE 2019
DRAWING No: PSE/EE1-03			REV: 1

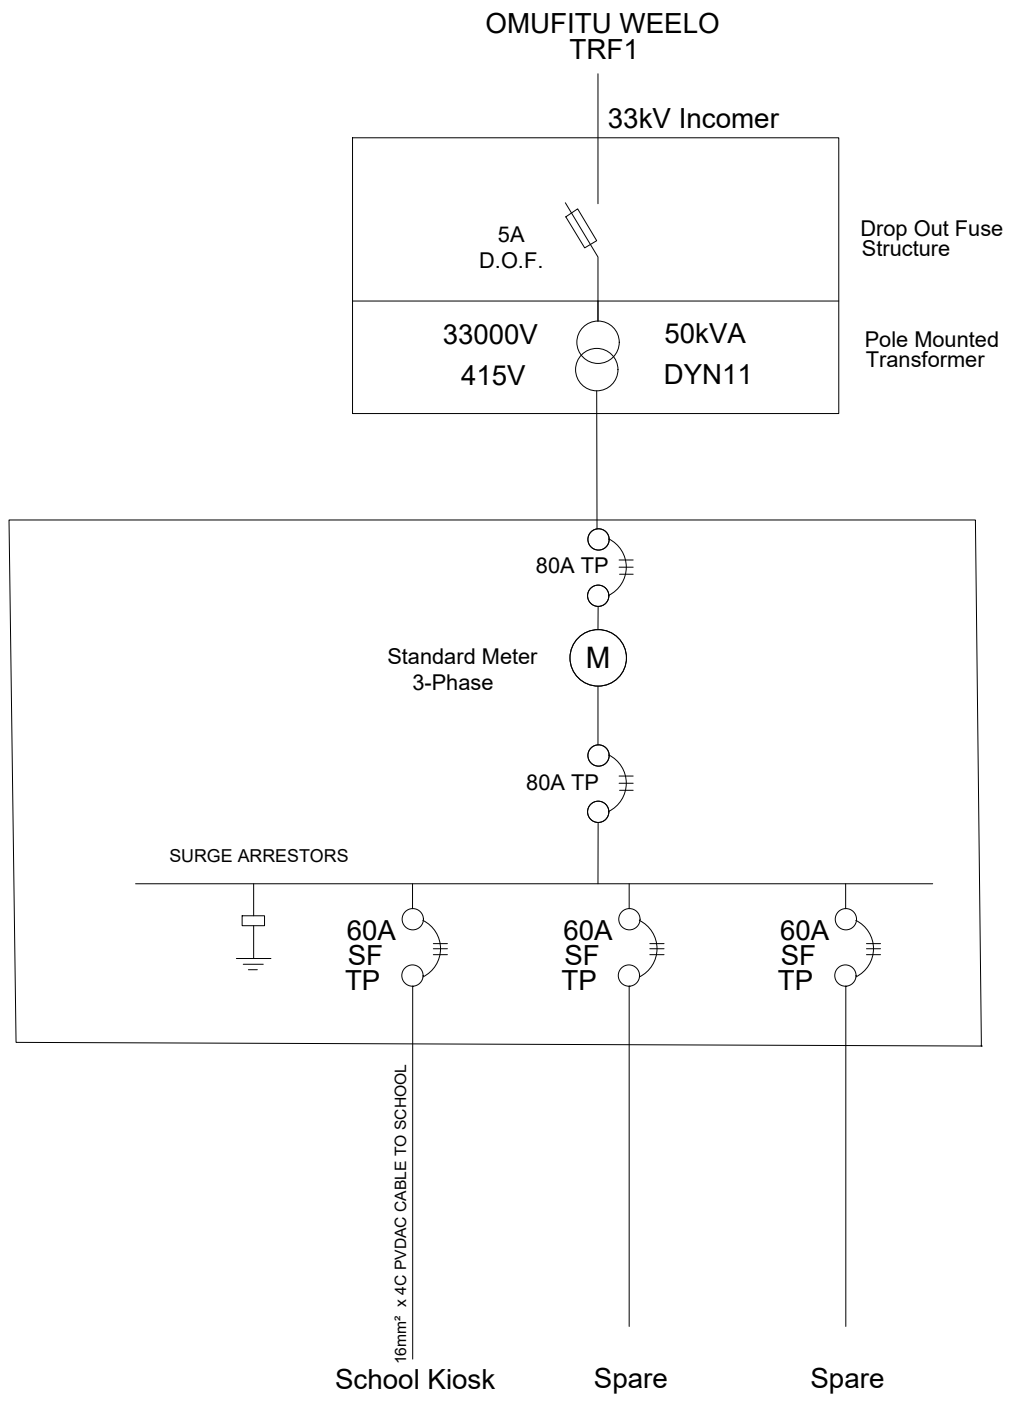

Pole Mounted
 Transformer
 Meter Board

School Kiosk Spare Spare


MV LINE UPGRADE SCALE :NTS

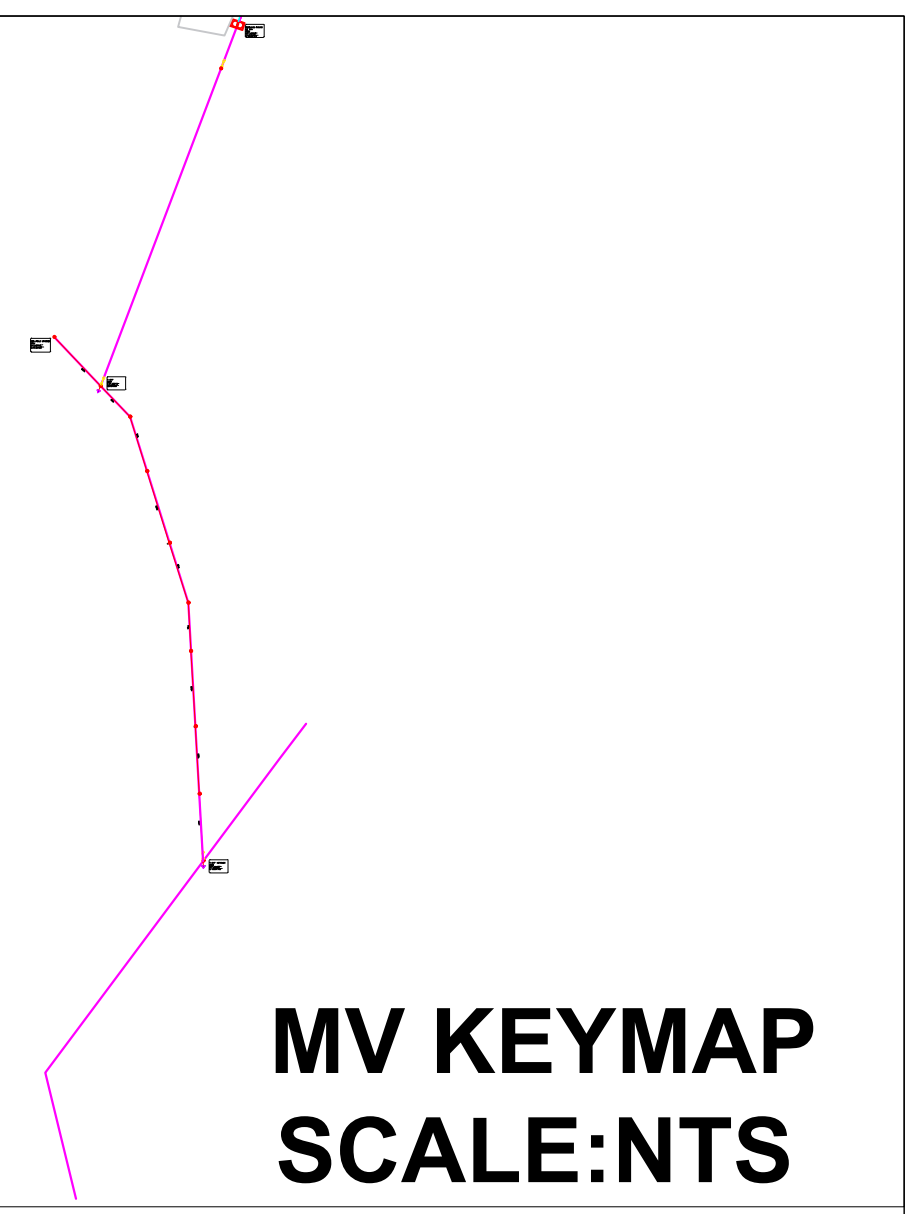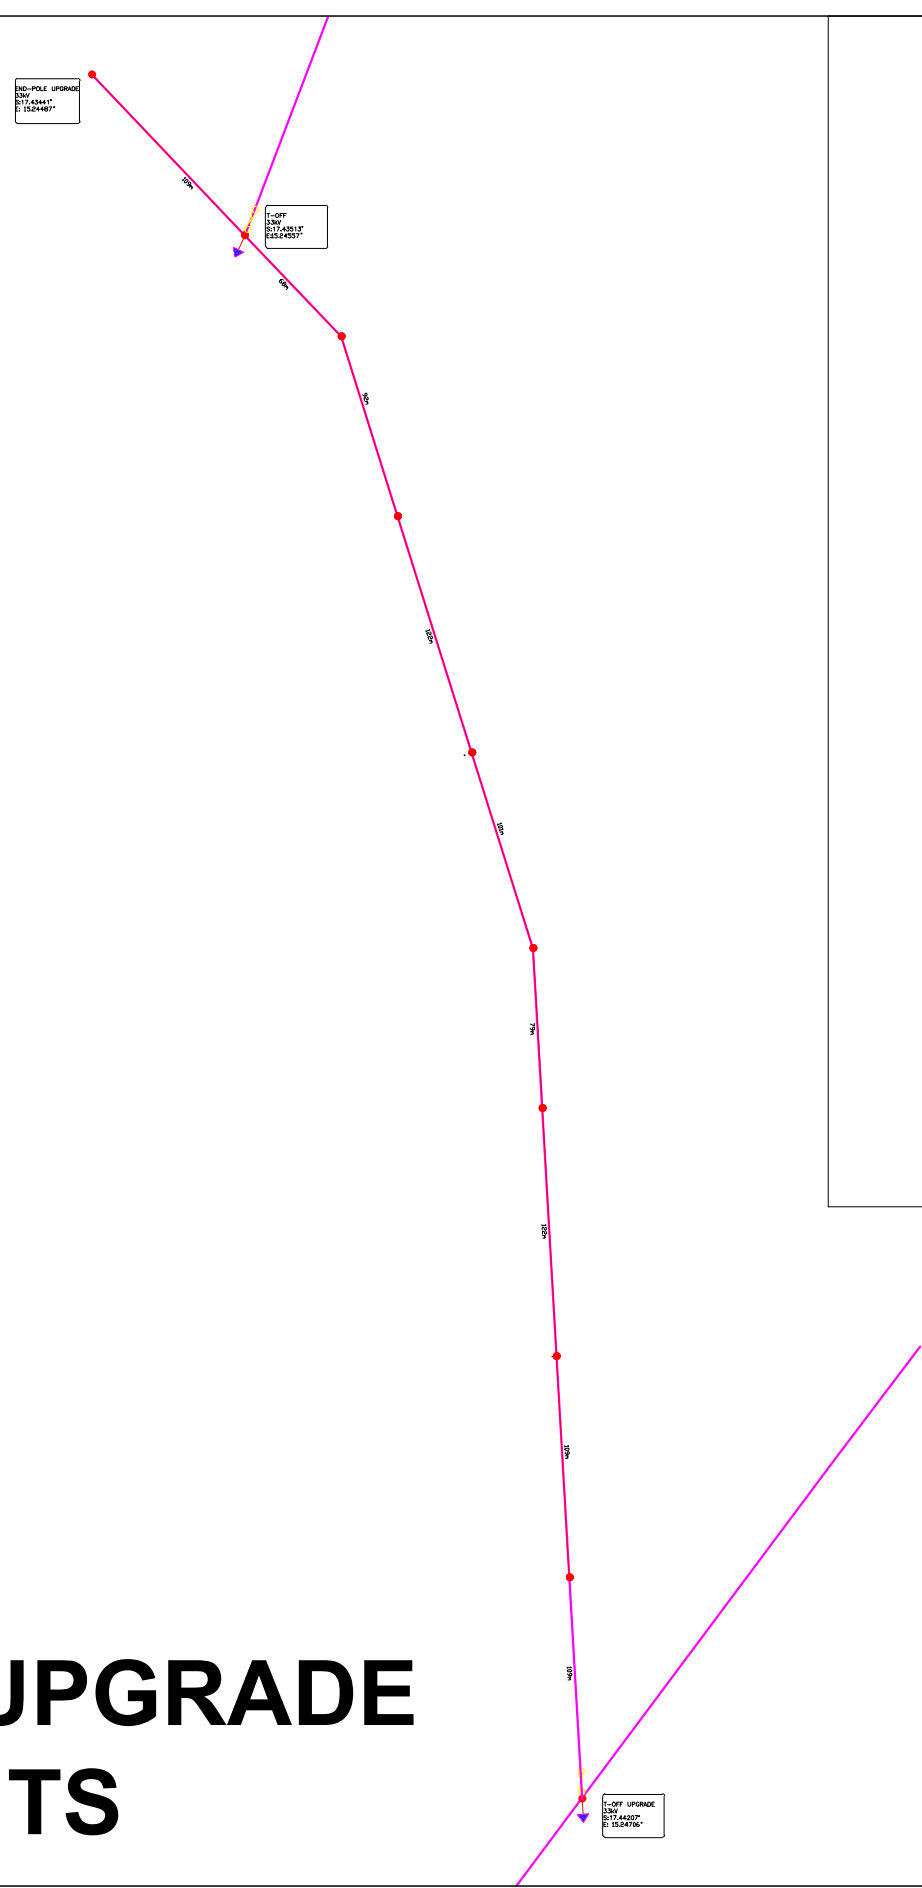


NOTES:


LEGEND	
SYMBOL	DESCRIPTION
	DROP OUT FUSE
	LOAD BREAK/SOLID LINKS
	MV POLE (11m@13m)
	MV STAY POLE ASSEMBLY
	POLE MOUNTED METER BOARD
	3.3 KV MV OH LINE
	TRANSFORMER
	EXISTING 11KV OVERHEAD LINE
	RAILWAY TRACKS

ELECTRICAL CONSTRUCTOR
FARADAY'S ELECTRICAL & MECHANICAL
 P O Box 22019, Windhoek
 Tel: (061)221 999
 Fax: (061)247 456



CLIENT

 Namibia Power Corporation (NAMPOWER)
 PO Box 2864
 WINDHOEK
 NAMIBIA
 TEL: +264 61 205 2206
 FAX: +264 61 205 2207

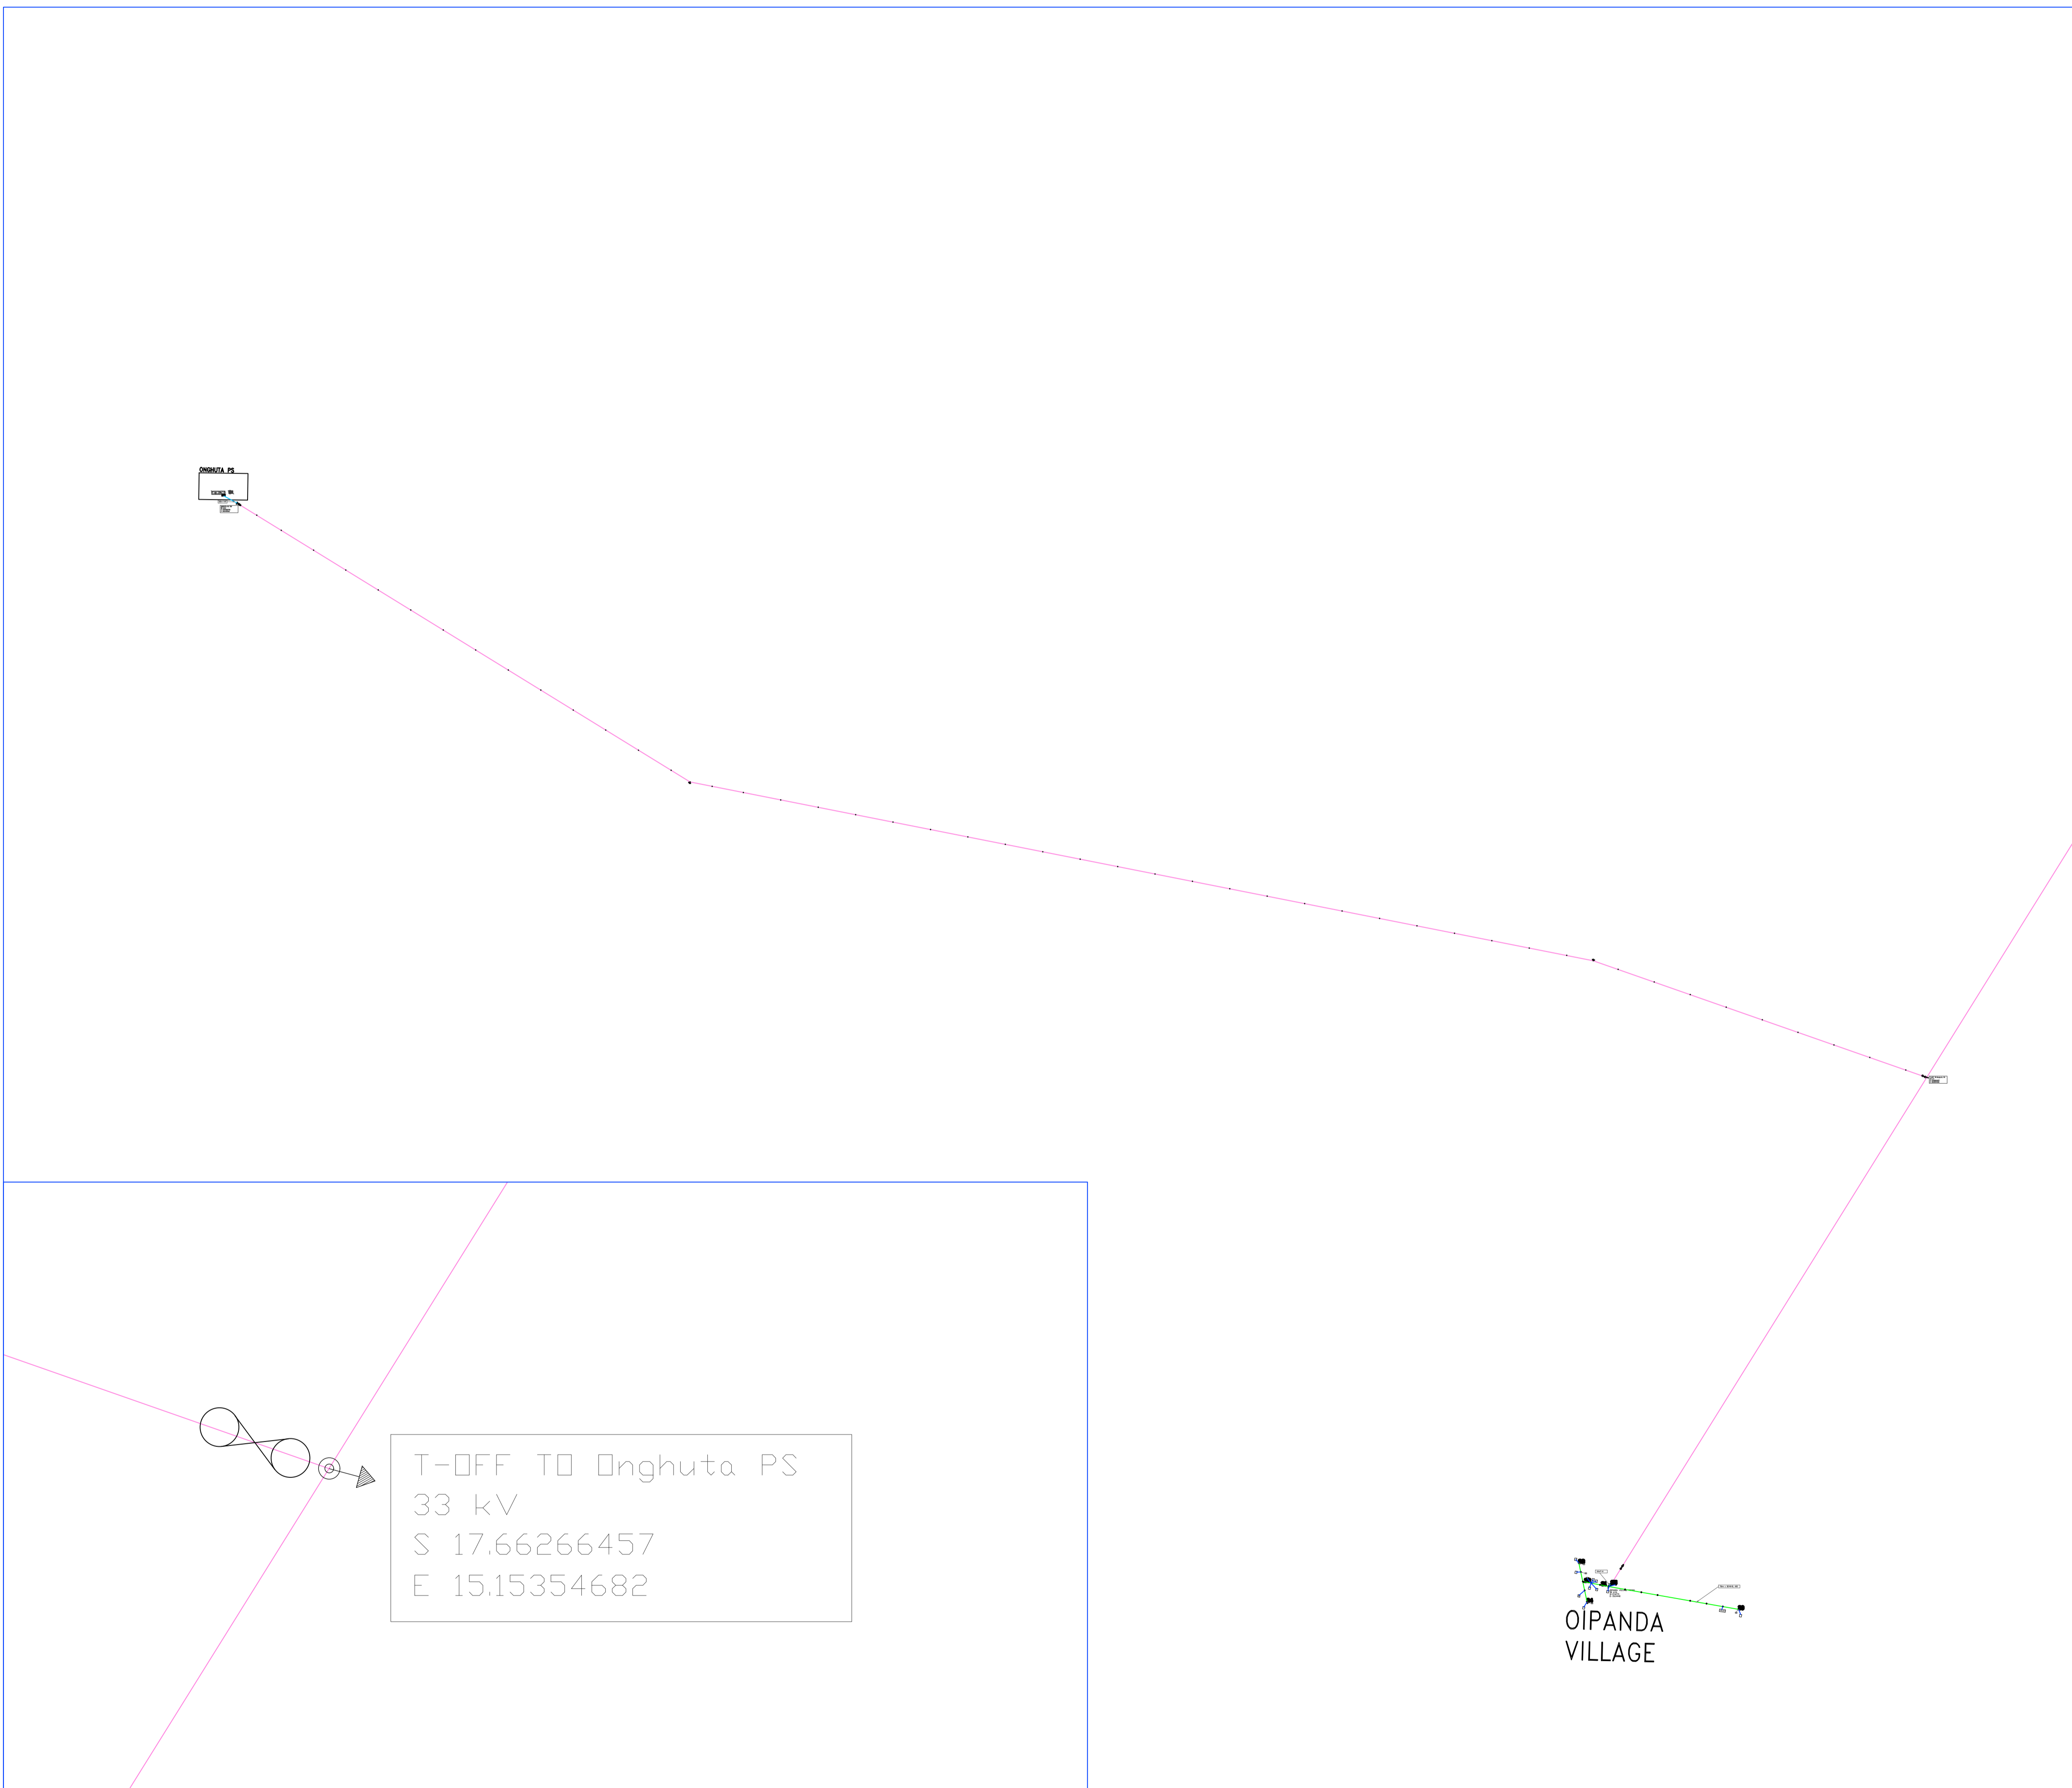PROJECT TITLE		
UPGRADE OF MEDIUM VOLTAGE LINES		
DRAWING TITLE		
MV AND KEYMAP DIAGRAM		
SCALE	DATE	
	JANUARY 2023	
DRAWN	CHECKED	
LS		
PROJECT NO.		
NPC CODE		
PROJECT NO.	DWG NO.	REVISION FOR APPROVAL




COPYRIGHT:
 COPYRIGHT © 2018 EMCON PSE CONSULTING
 ALL RIGHTS RESERVED. NO PART OF THIS DRAWING MAY BE REPRODUCED STORED IN A RETRIEVAL SYSTEM OR TRANSMITTED IN ANY FORM OR BY ANY MEANS ELECTRONIC, ELECTROSTATIC, MAGNETIC TAPE, MECHANICAL, PHOTOCOPIING, RECORDING OR OTHERWISE, WITHOUT THE WRITTEN PERMISSION OF EMCON.

LEGEND:

Symbol	Description	QTY
	33kV LINE	
	22kV LINE	
	19.1kV SWER LINE	
	11kV OVERHEAD LINE	
	11kV LINE UNDERGROUND	
	400V ABC LINE	
	OVERHEAD SERVICE CABLE	
	UNDERGROUND SERVICE CABLE	
	TELEPHONE LINE	
	TRANSFORMER	
	LINKED FUSE (15A, TYPE K)	
	LOAD BREAK UNIT	
	STREET LIGHTS	
	LV POLE	
	MV POLE	
	KIOSK	
	FLY STAY STRUCTURE	
	STAY ASSEMBLY FOR 11kV LINE	
	STRUT ASSEMBLY FOR 11kV LINE	
	STAY ASSEMBLY FOR ABC LINE WITH WARNING PIPE	
	STRUT ASSEMBLY FOR ABC LINE	
	SLEEVES	
	8m KICK POLE FOR AIRDAC	
	5m KICK POLE FOR AIRDAC	
	KIOSK	
	DISTRIBUTION BOARD TYPE "A OR B" POLE MOUNTED	
	BRICK HOUSE	
	SINK HOUSE	
	WOOD HOUSE	

No.	REVISIONS	APP.	DATE

CLIENT:



NamPower

P.O BOX 2864 Windhoek NAMIBIA
 Tel: (061) 2054111 Fax: (061) 232805

APPROVED BY CLIENT _____ DATE _____
 COPYRIGHT RESERVED

EMCON PSE CONSULTING



POWER PLANNING UNIT

Box 1900 Windhoek NAMIBIA
 4 Bossingthwaighte Street Klein Windhoek
 Tel: (061) 224725 Fax: (061) 233207
 E-mail: emcon@emcgroup.com


PROJECT

NAMPOWER 2018 RURAL ELECTRIFICATION
 OMUSATI REGION

DRAWING TITLE

ELECTRICAL KEYMAP FOR
 ONGHUTA PS
 S: -17.64602756
 E: 15.10405166

DESIGNED:P.H	DRAWN:P.H	CHECKED:H.H	SCALE:N.T.S
CONSULTANT PROJ. No:PP 237D			DATE:JUN 2018
DRAWING No: PSE/2018/00/EE1-01			REV: 00

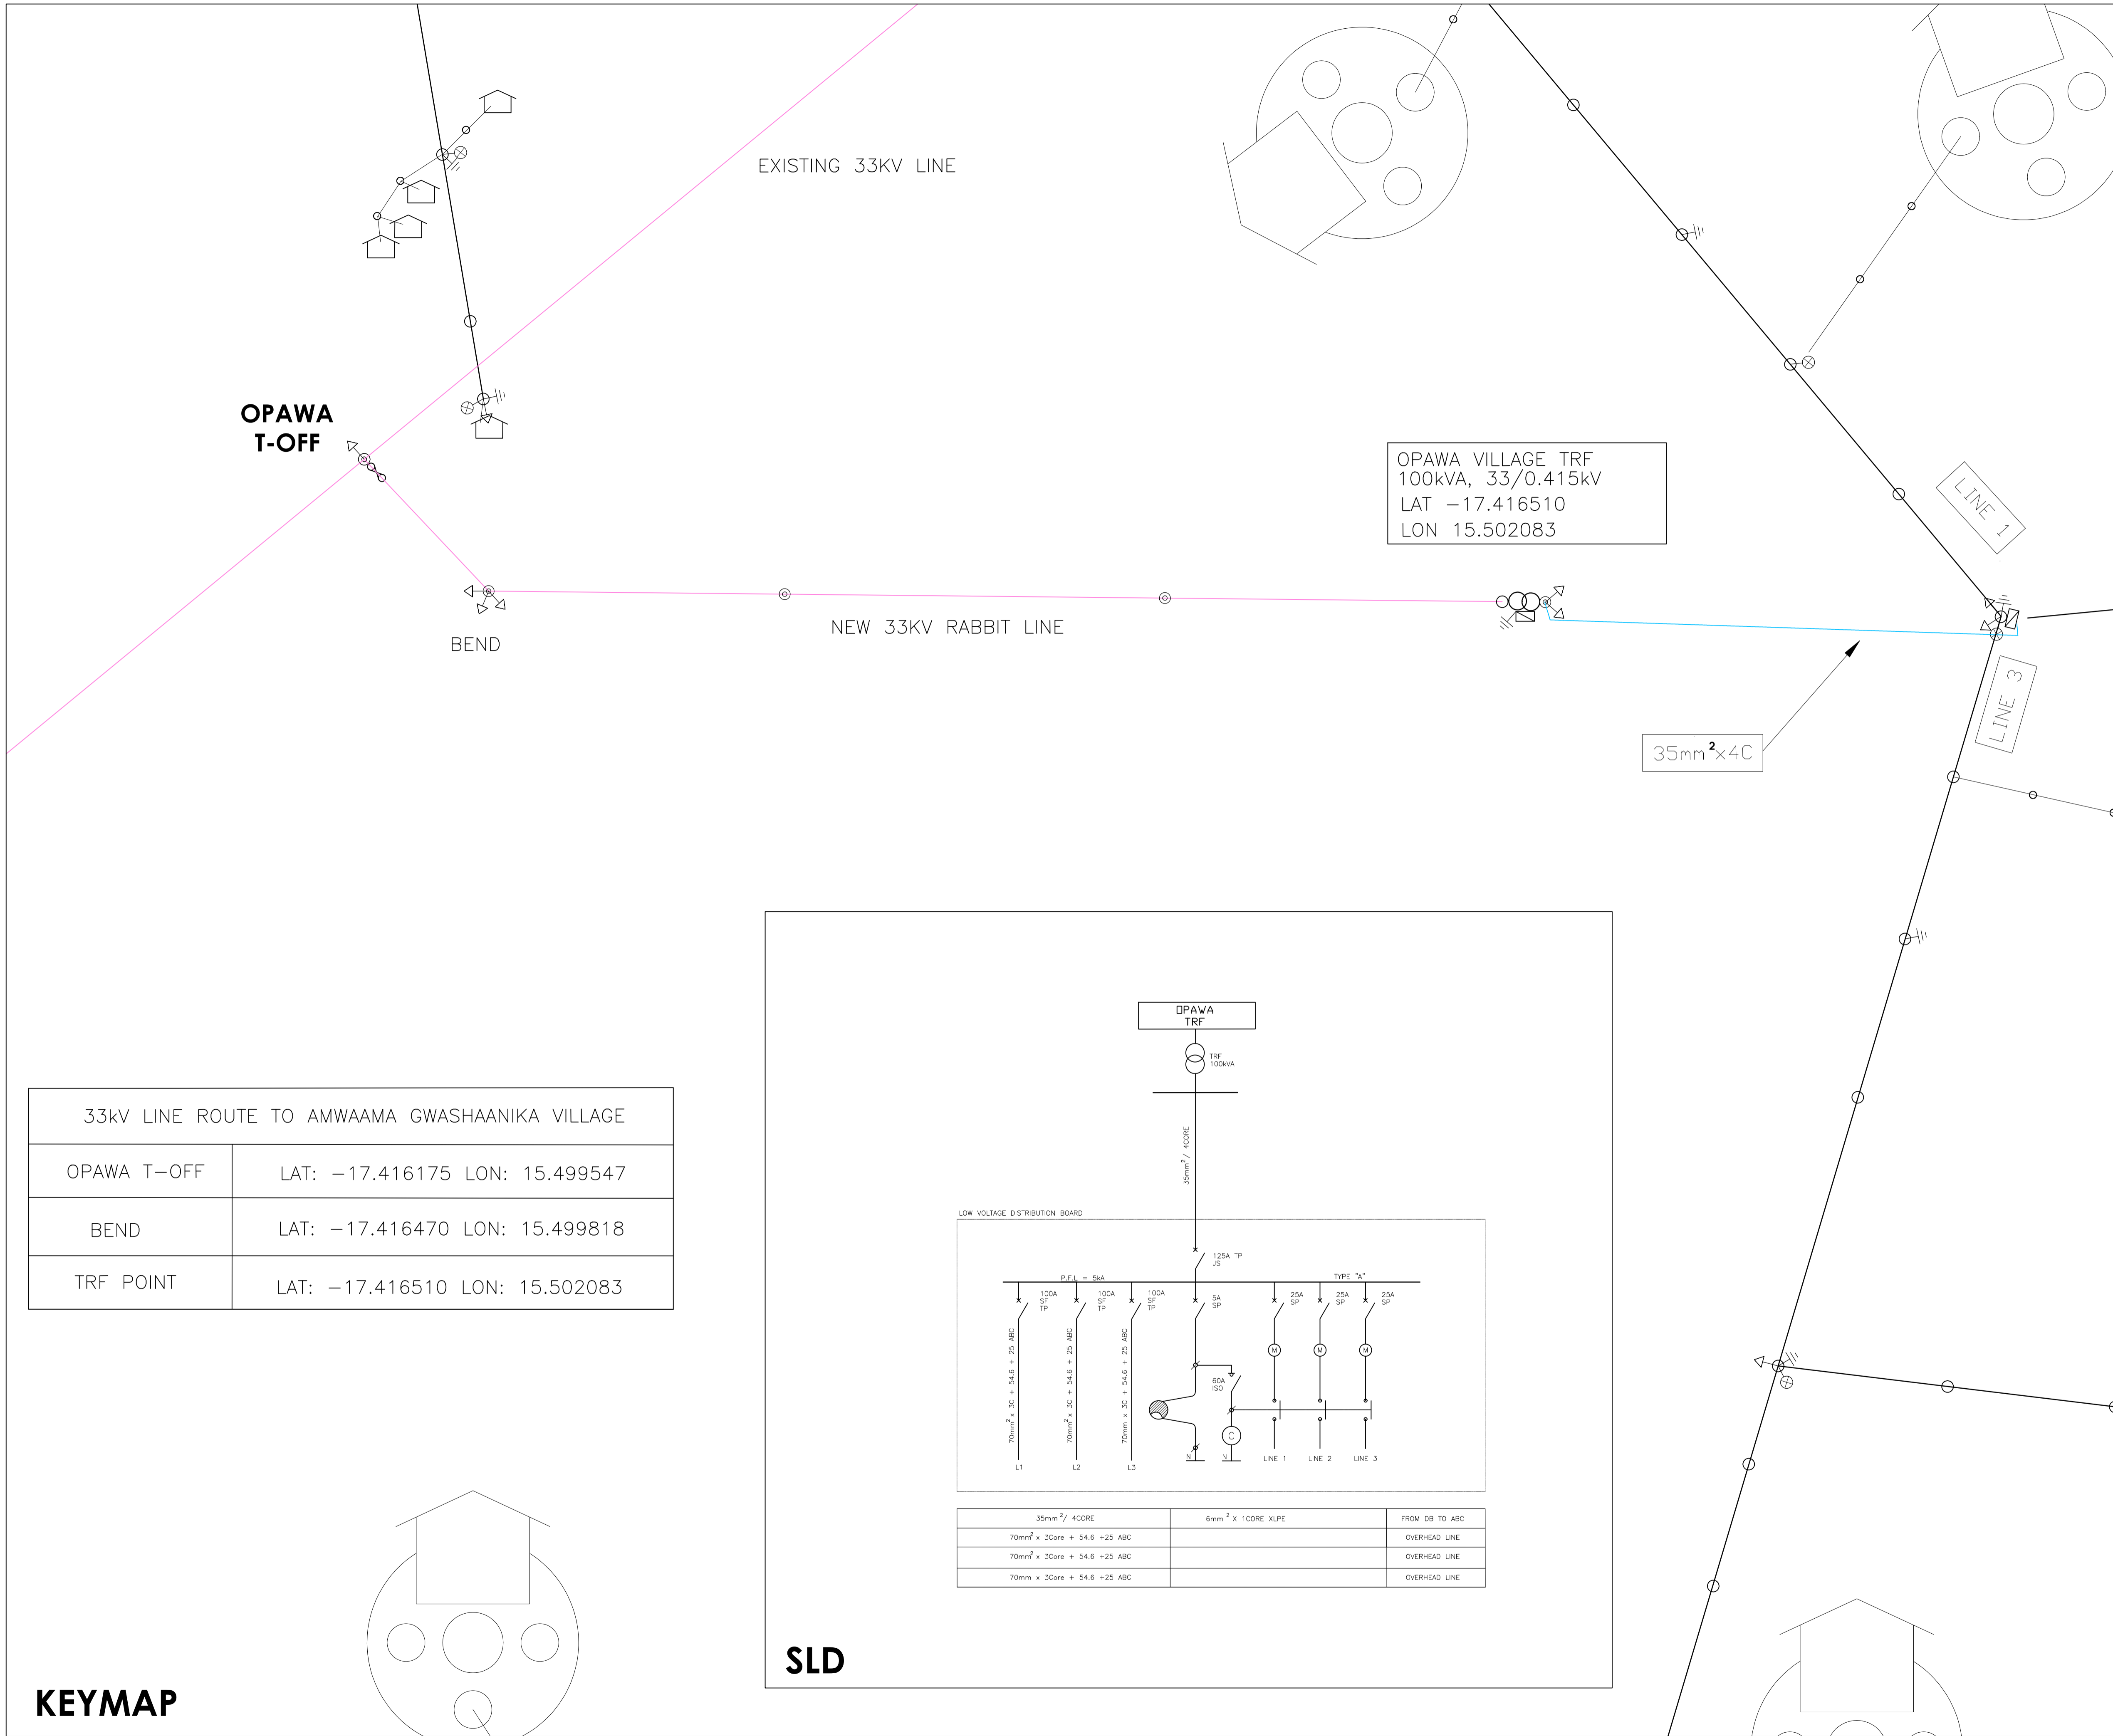

OPAWA VILLAGE TRF
100kVA, 33/0.415kV
LAT -17.416510
LON 15.502083

OPAWA
T-OFF

BEND

EXISTING 33KV LINE


NEW 33KV RABBIT LINE

35mm²x4C

LINE 1

LINE 3

33KV LINE ROUTE TO AMWAAMA GWASHAANIKA VILLAGE	
OPAWA T-OFF	LAT: -17.416175 LON: 15.499547
BEND	LAT: -17.416470 LON: 15.499818
TRF POINT	LAT: -17.416510 LON: 15.502083

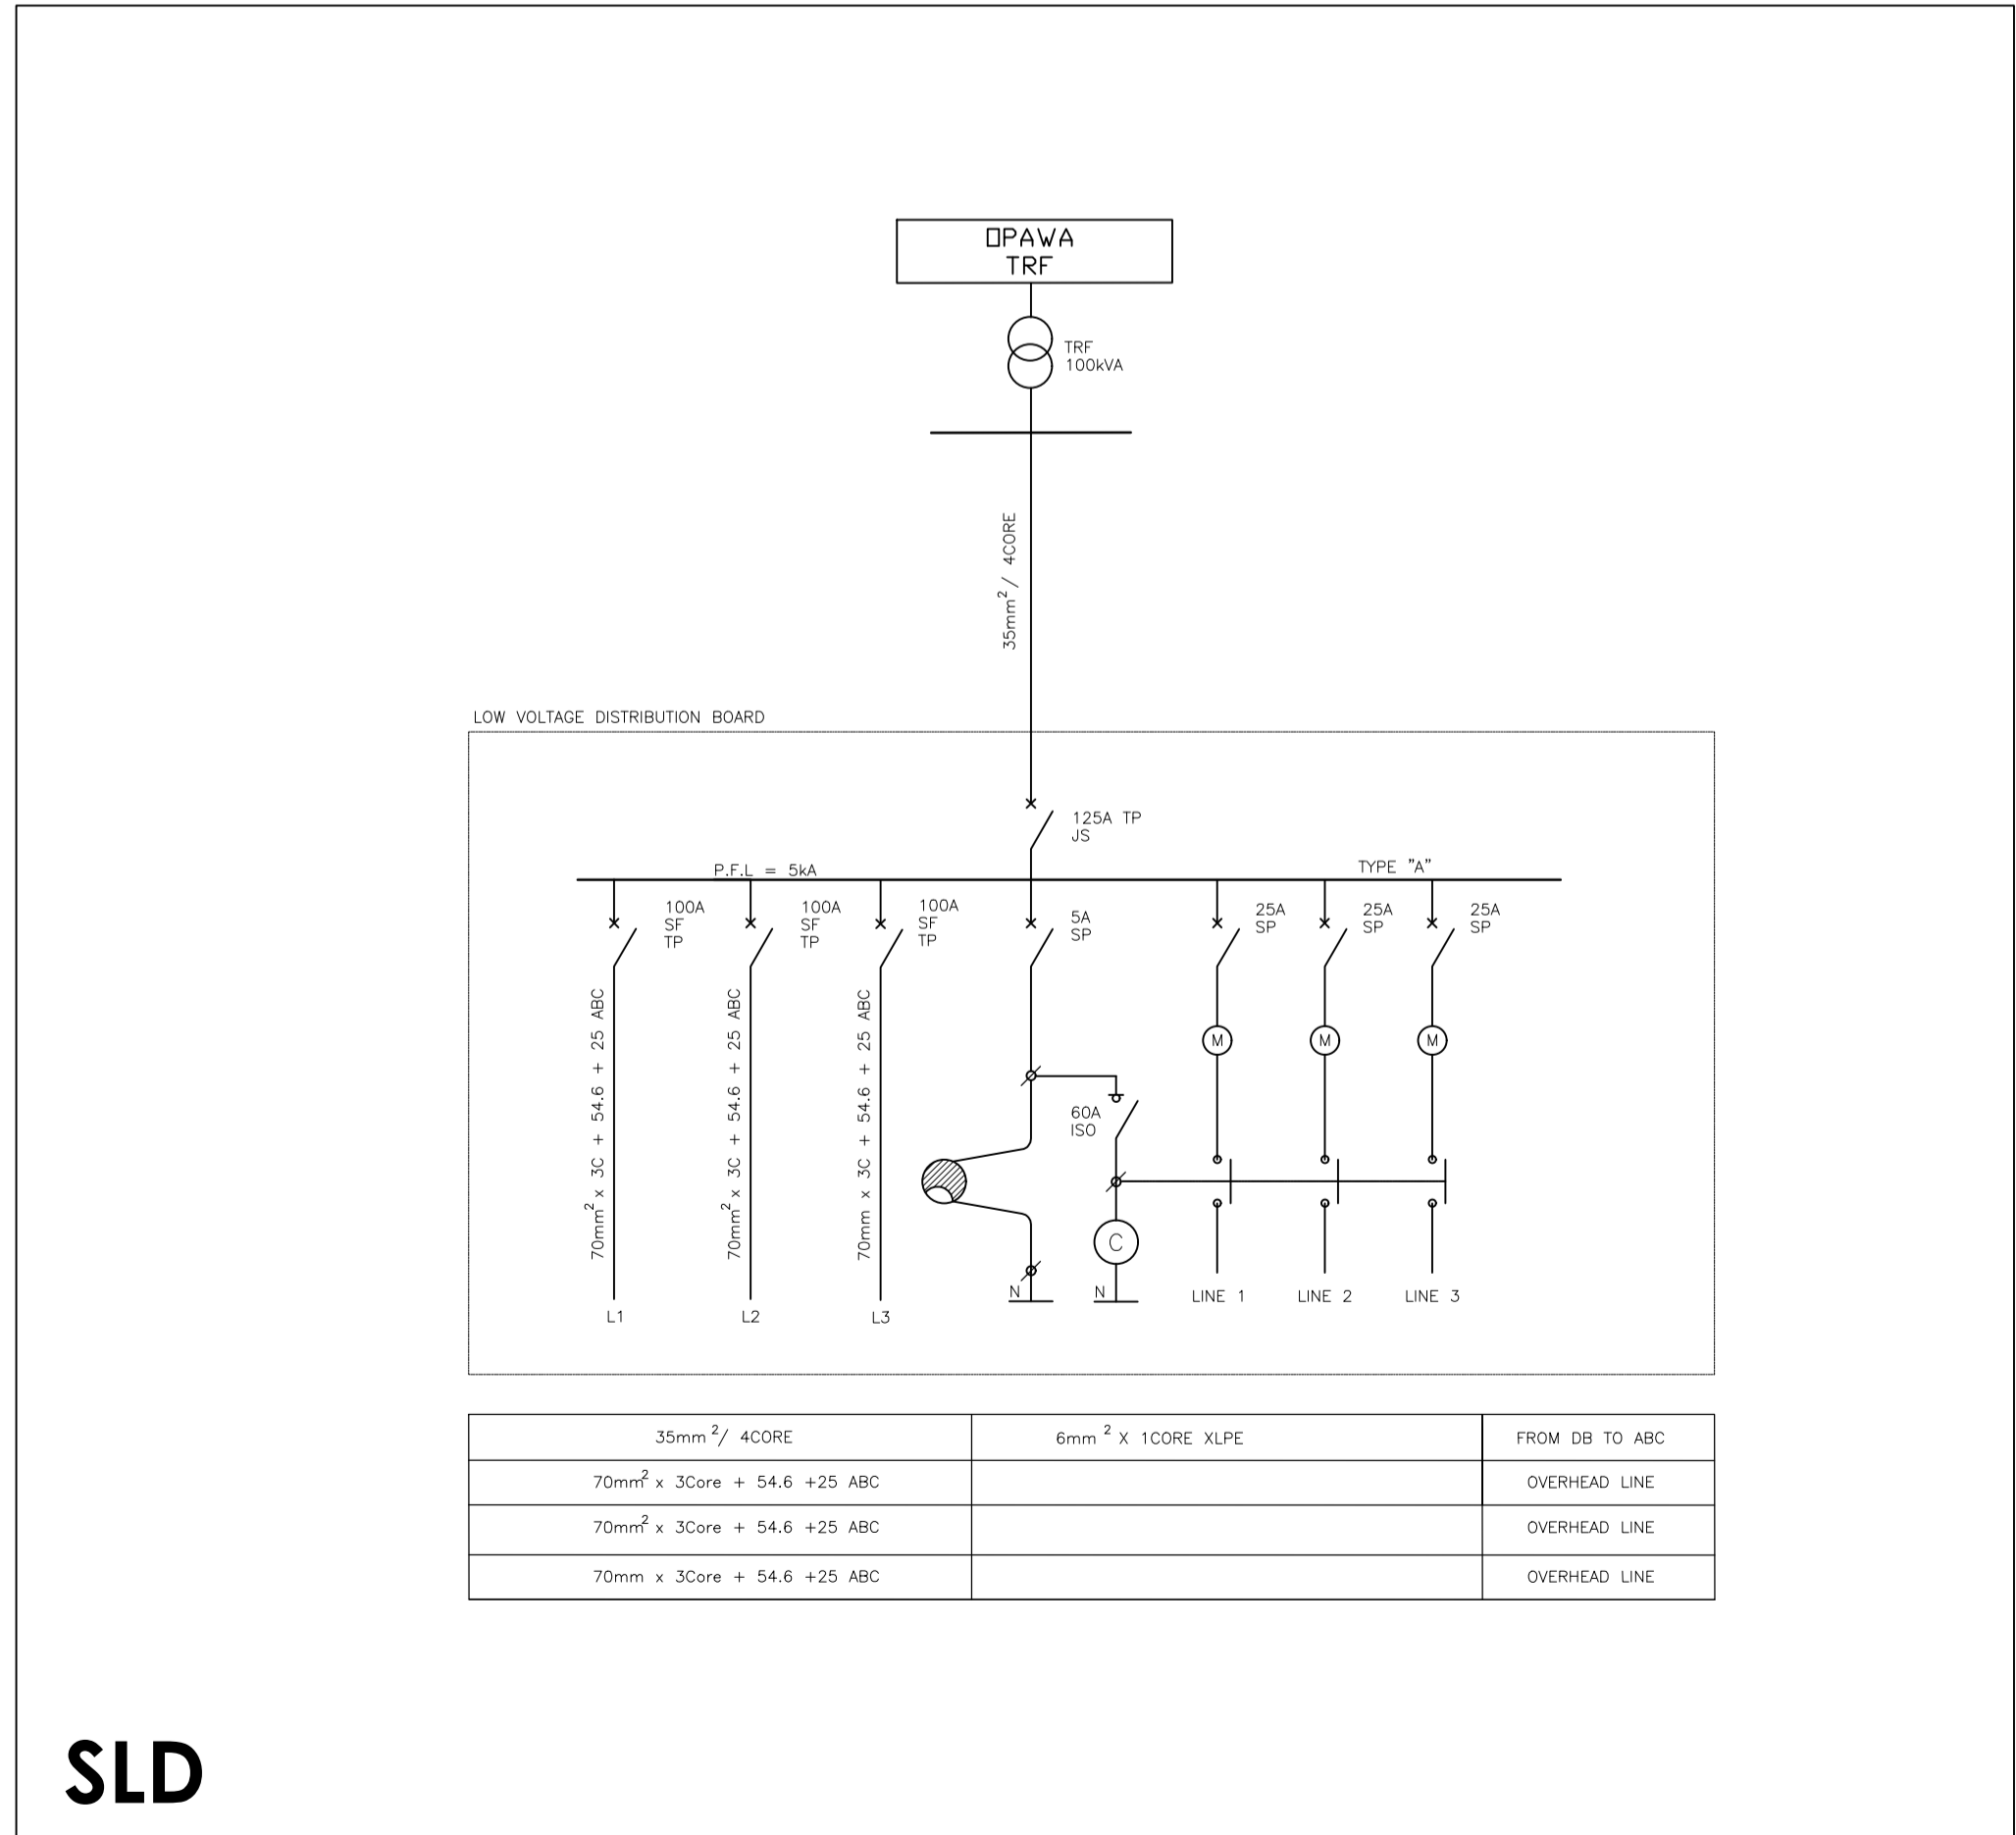

SLD

KEYMAP

COPYRIGHT:
COPYRIGHT © 2019 EMCON PSE CONSULTANTS
ALL RIGHTS RESERVED. NO PART OF THIS DRAWING MAY BE REPRODUCED STORED IN A RETRIEVAL SYSTEM OR TRANSMITTED IN ANY FORM OR BY ANY MEANS ELECTRONIC, ELECTROSTATIC, MAGNETIC TAPE, MECHANICAL, PHOTOCOPIING, RECORDING OR OTHERWISE, WITHOUT THE WRITTEN PERMISSION OF EMCON.

Legend:

	33KV LINE
	22KV LINE
	19.1KV SNER LINE
	11KV OVERHEAD LINE
	11KV LINE UNDERGROUND
	400V ABC LINE
	OVERHEAD SERVICE CABLE
	UNDERGROUND SERVICE CABLE
	TELEPHONE LINE
	TRANSFORMER
	LINKED FUSE (15A, TYPE K)
	LOAD BREAK UNIT
	STREET LIGHTS
	LV POLE
	MV POLE
	KIOSK
	FLY STAY STRUCTURE
	STAY ASSEMBLY FOR 11KV LINE
	STAY ASSEMBLY FOR 11KV LINE WITH WARNING ROPE
	STAY ASSEMBLY FOR ABC LINE WITH WARNING ROPE
	SLEEVES
	8m KICK POLE FOR AIRGAC
	5m KICK POLE FOR AIRGAC
	KIOSK
	DISTRIBUTION BOARD TYPE "A" OR "B"
	POLE MOUNTED BRICK HOUSE
	POLE MOUNTED WOOD HOUSE

Client

NamPower
Powering the Nation and beyond

Namibia Power Corporation (Proprietary) Limited
P.O. Box 2864, Windhoek - 15 Luther Street Windhoek
T: +264 61 205 4113 F: +264 61 202 905

USER CLIENT

NORED ELECTRICITY (PTY) Ltd
P.O. Box 639, Ondangwa Namibia - Main Road Ondangwa
T: +264 65 282 2100 F: +264 65 282 2145

USER CLIENT APPROVAL

APPROVAL PERSONEL: _____ APPROVAL DATE: ____/____/2019

Project
RURAL ELECTRIFICATION OPAWA, PANDULENI AND OTAADHIYA- OMUSATI REGION

Revisions

No.	Description	Drawing Title	Date
0	For tender	Opawa Village Keymap and SLD	07/07/21
1	For construction	Opawa Village Keymap and SLD	18/06/20
2	For As Built	Opawa Village Keymap and SLD	18/03/22


Electrical & Mechanical Engineers

EMCON (Proprietary) Limited - Reg No. 2012/0929
P.O. Box 1900, Windhoek - 4 Basingshwaighe Str. - Main Windhoek
T: +264 61 224 725 F: +264 88 651 6173 contact@emcongroup.com


Drawing title
OPAWA VILLAGE KEYMAP AND SINGLE LINE DIAGRAM

Project number:	Scale	Drawing number:
PP239B	N.T.S	NPWR 21/2020-001
	Revision	
	2	

Designed by: MGA Drawn by: MGA Checked by: HH

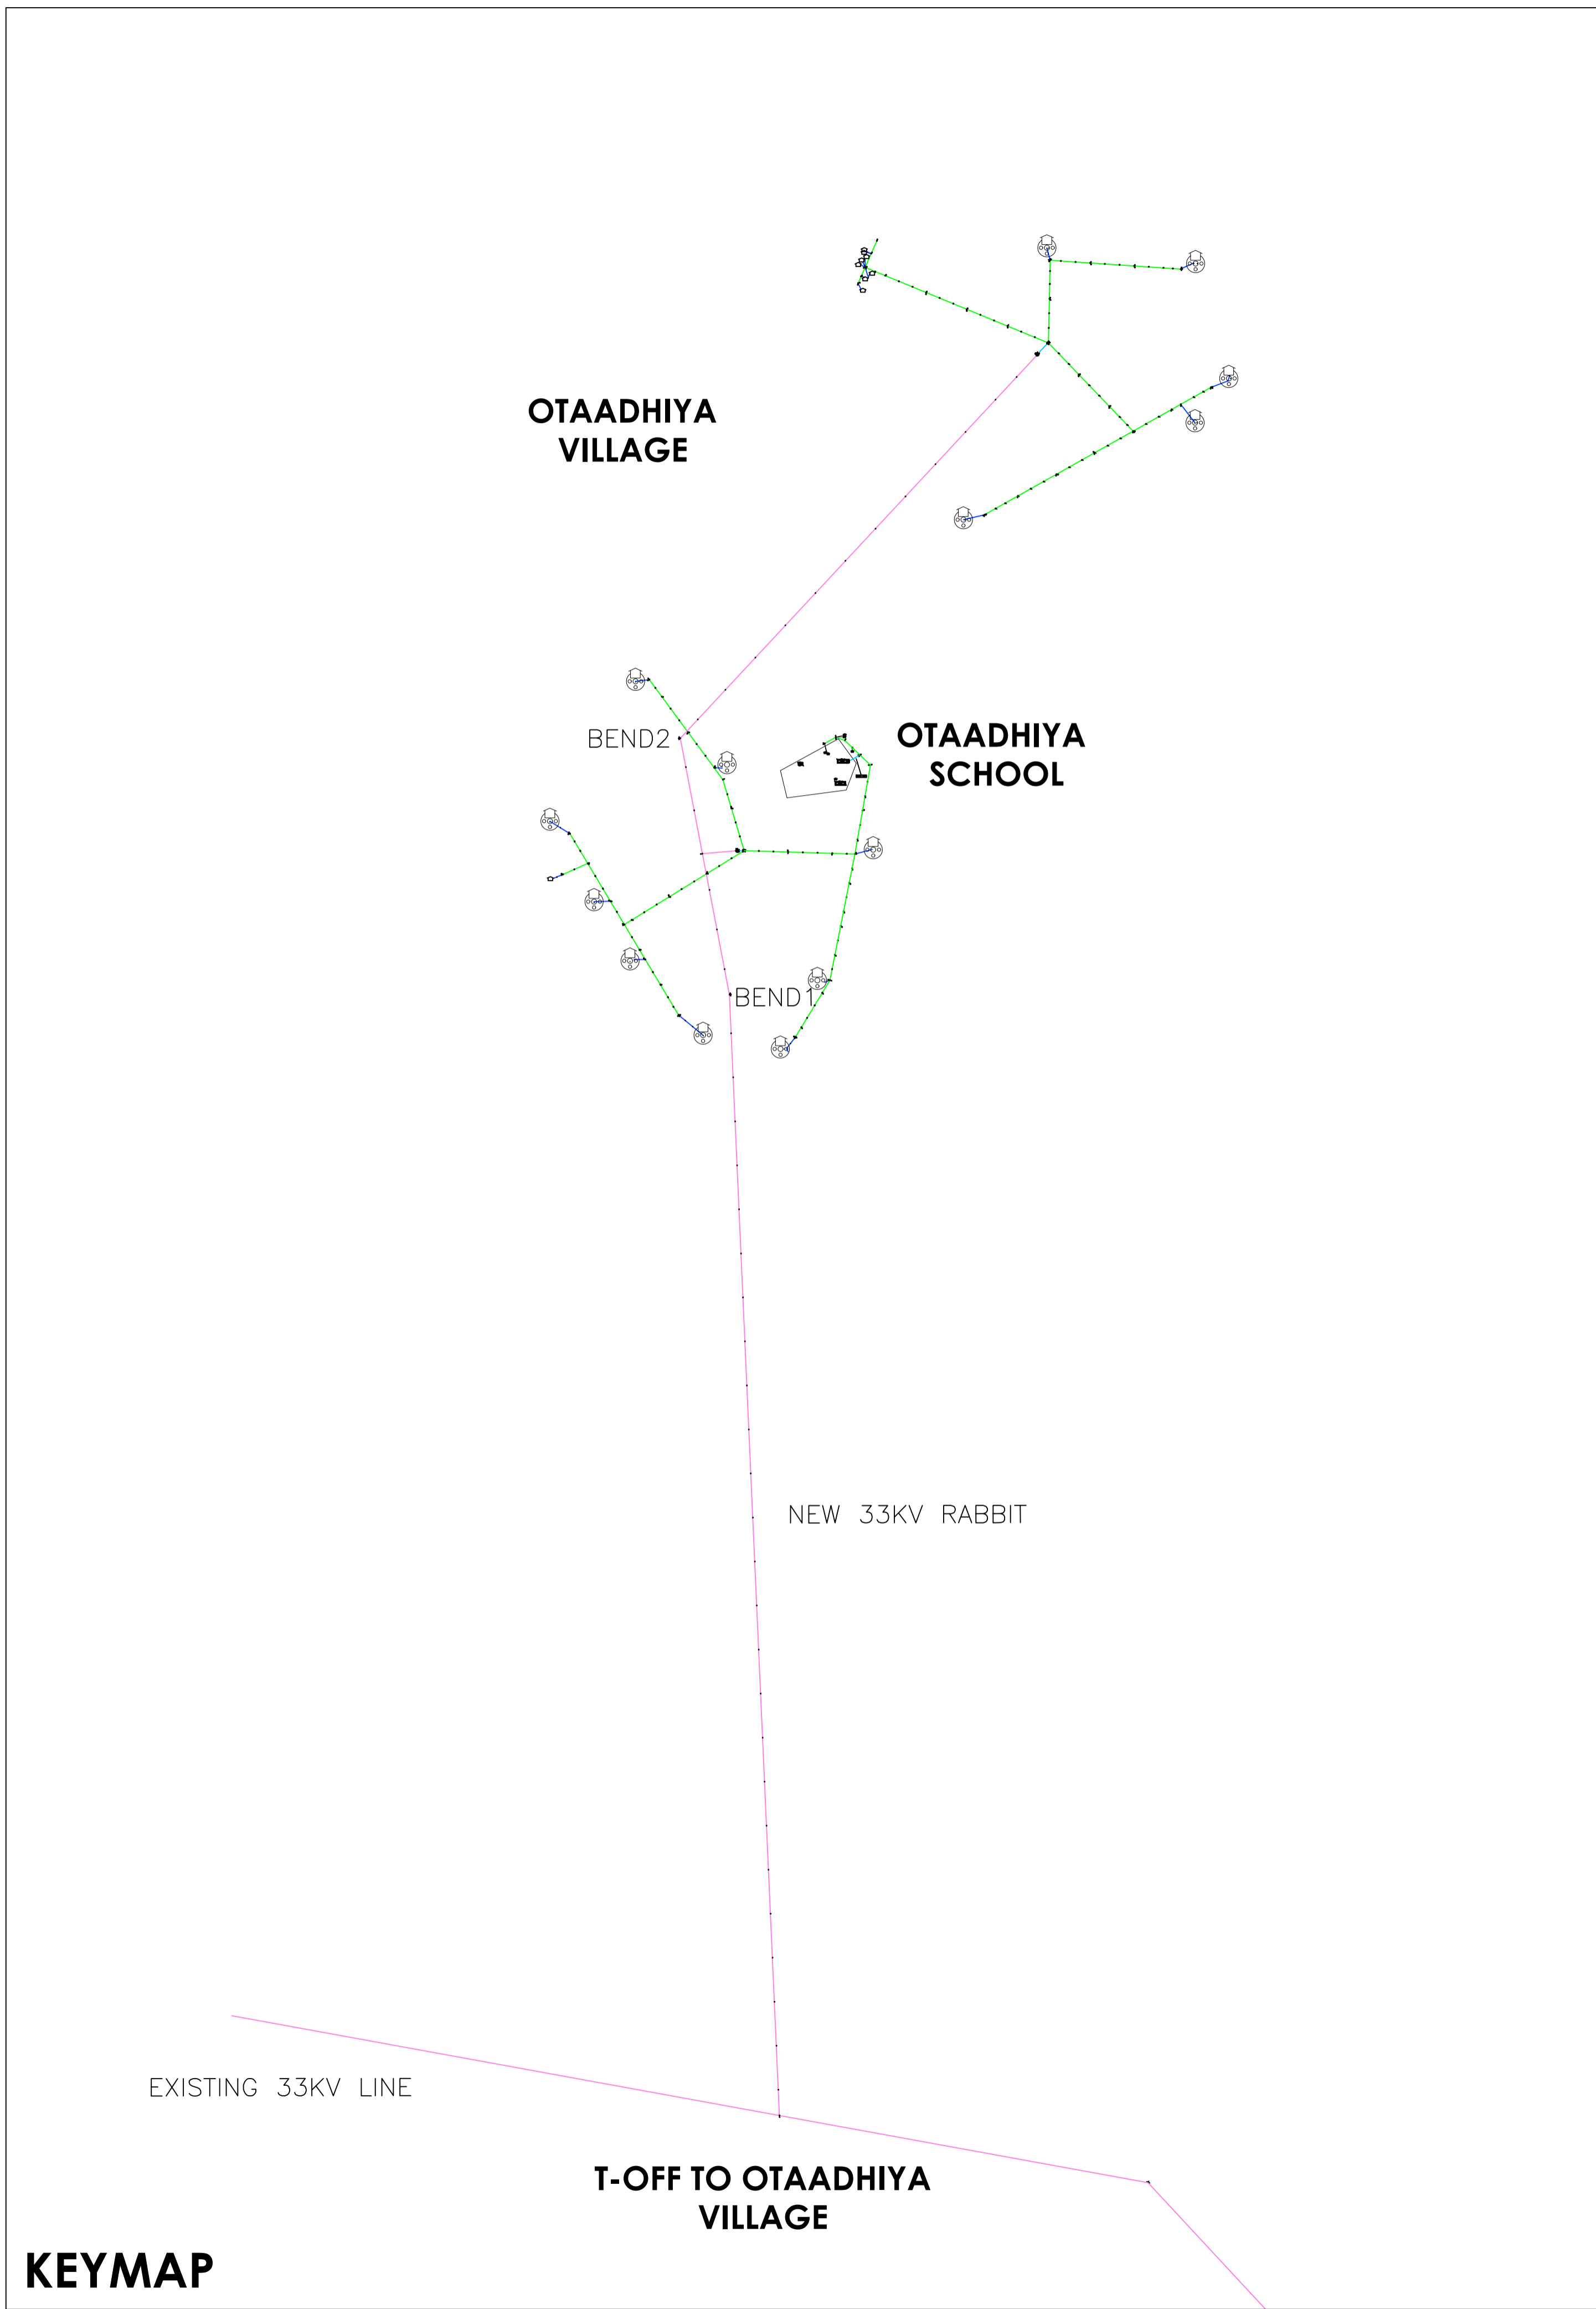

33kV LINE ROUTE TO ÒTAADHIYA VILLAGE	
NEW T-OFF	LAT: -17.760808 LON: 15.175806
BEND 1	LAT: -17.733220 LON: 15.174798
T-OFF 1	LAT: -17.729752 LON: 15.174143
TRF POINT 1	LAT: -17.729683 LON: 15.175028
BEND 2	LAT: -17.726905 LON: 15.173602
TRF POINT 2	LAT: -17.717585 LON: 15.182843

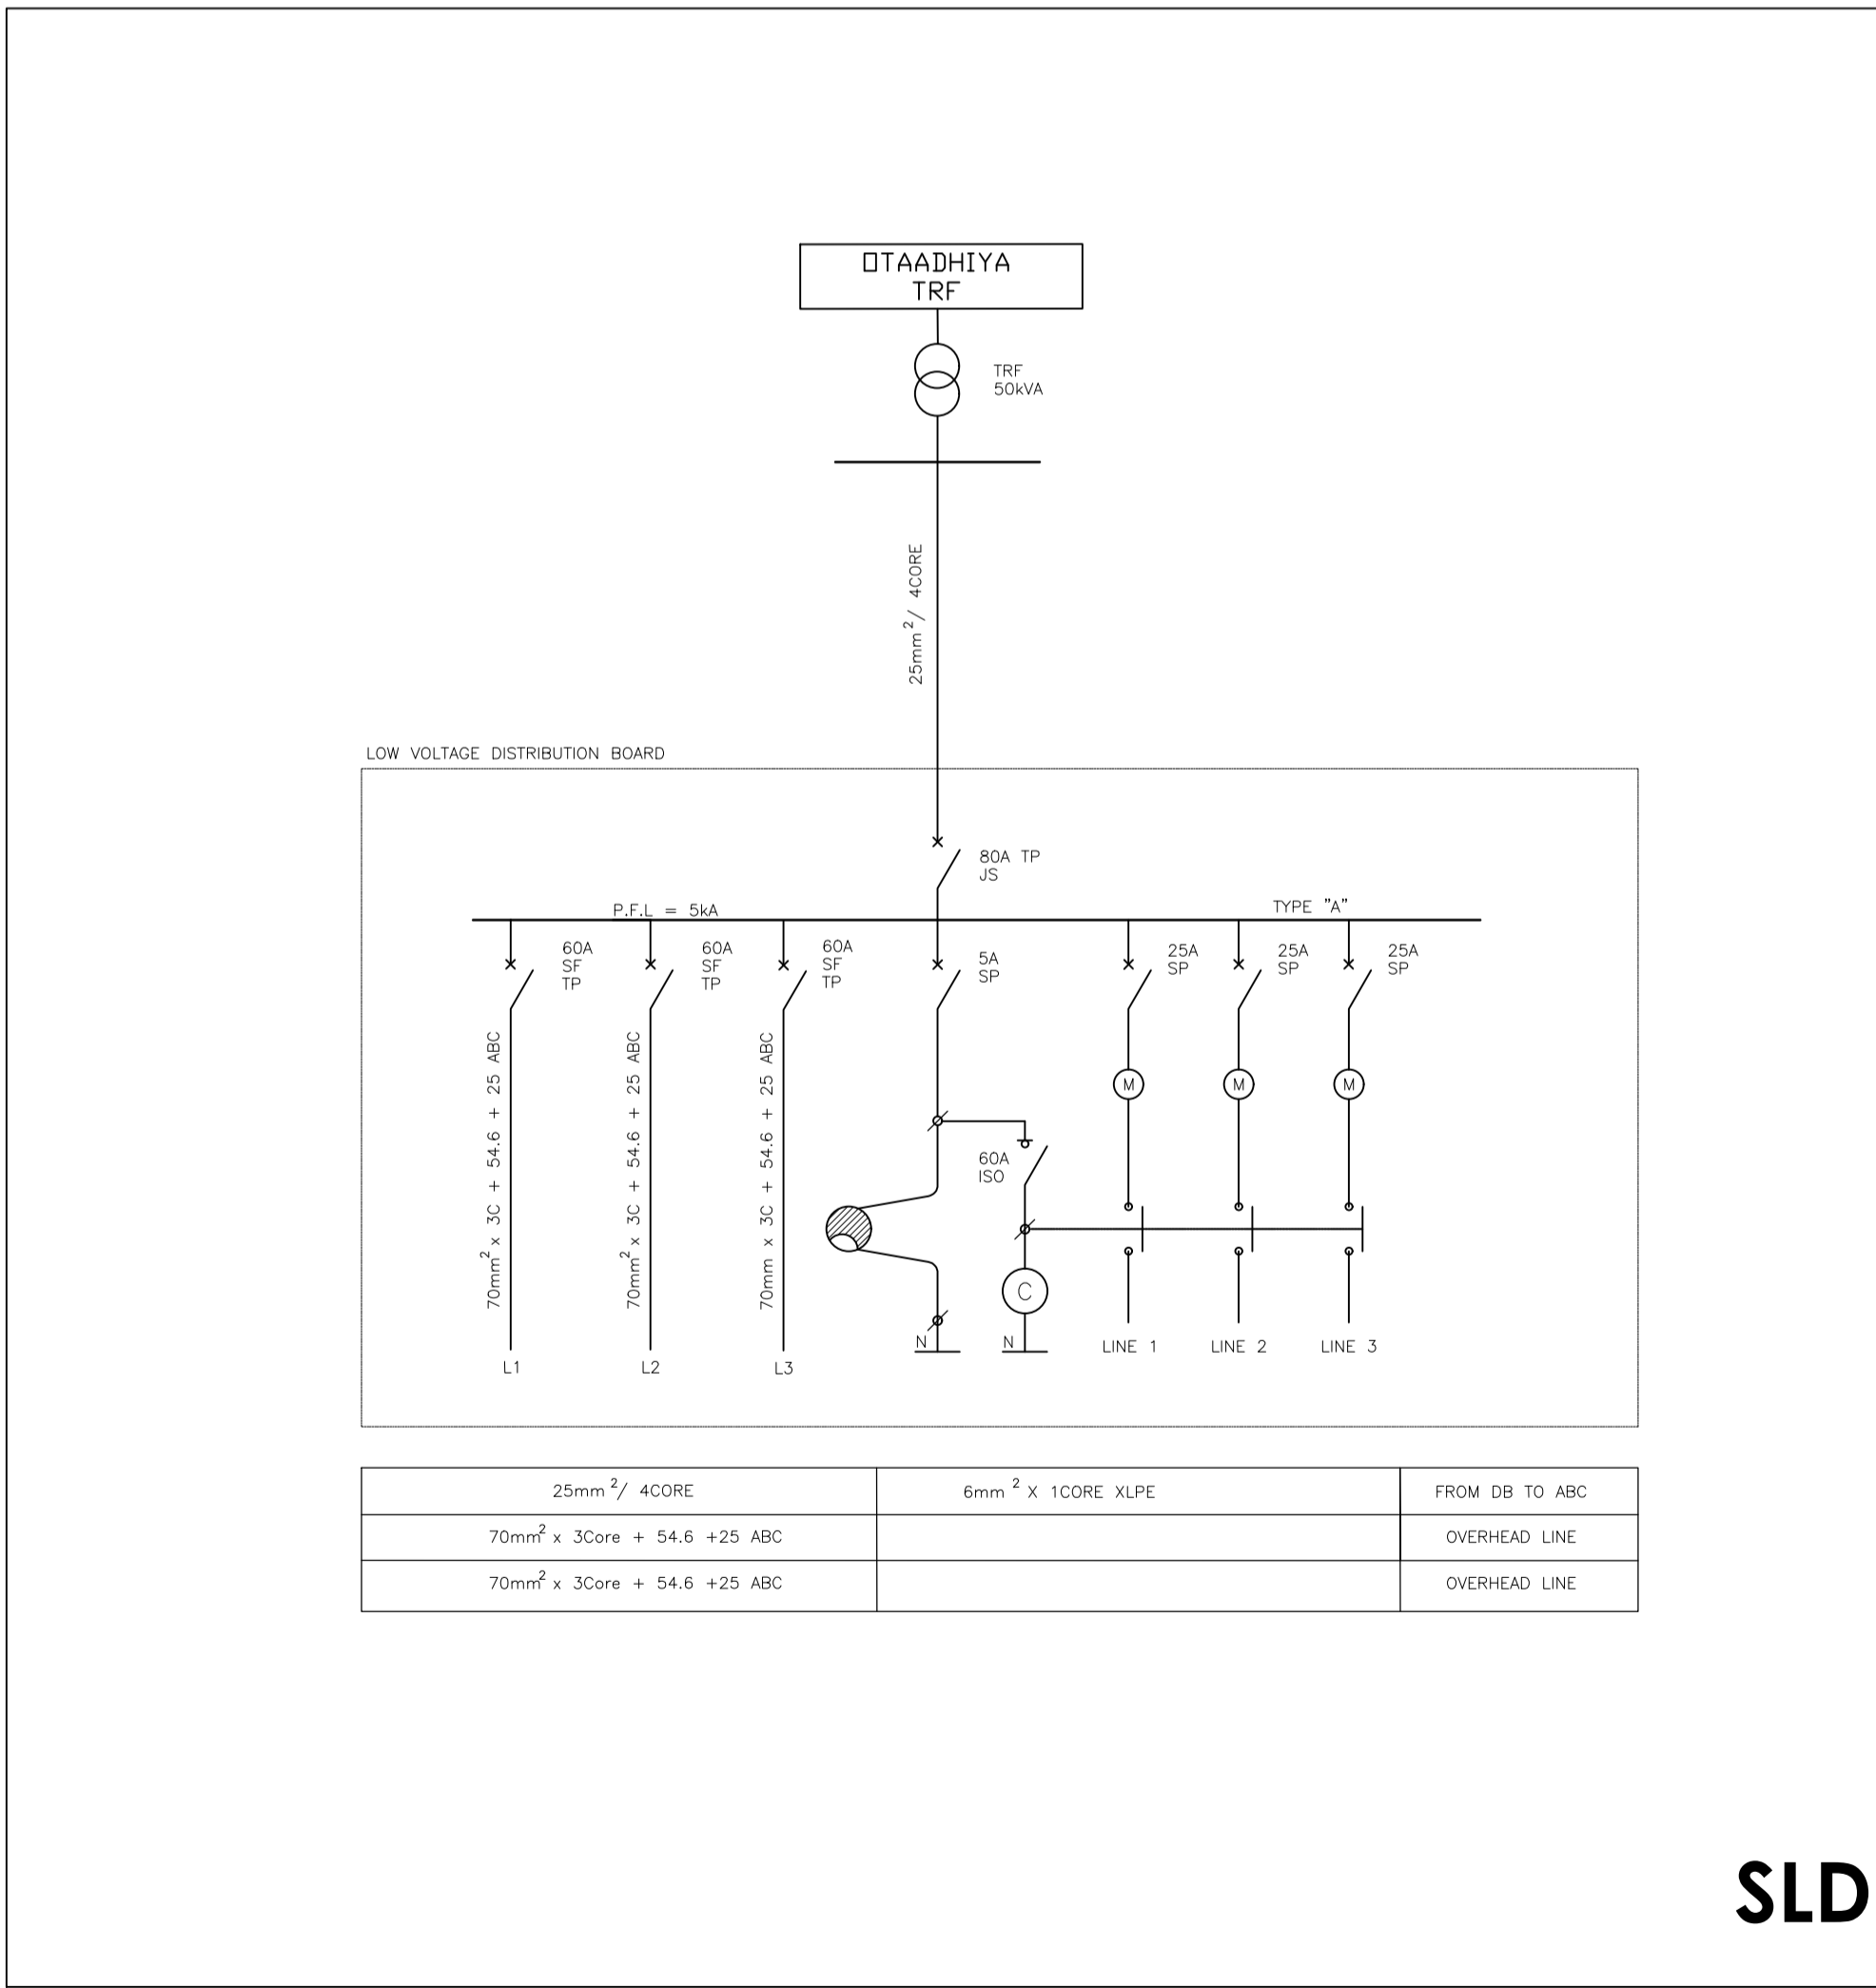

SLD

COPYRIGHT:
 COPYRIGHT © 2019 EMCON PSE CONSULTANTS
 ALL RIGHTS RESERVED. NO PART OF THIS DRAWING MAY BE REPRODUCED STORED IN A RETRIEVAL SYSTEM OR TRANSMITTED IN ANY FORM OR BY ANY MEANS ELECTRONIC, ELECTROSTATIC, MAGNETIC TAPE, MECHANICAL, PHOTOCOPIING, RECORDING OR OTHERWISE, WITHOUT THE WRITTEN PERMISSION OF EMCON.

Legend:

	33kV LINE
	22kV LINE
	15.1kV SHER LINE
	11kV OVERHEAD LINE
	11kV LINE UNDERGROUND
	400V ABC LINE
	OVERHEAD SERVICE CABLE
	UNDERGROUND SERVICE CABLE
	TELEPHONE LINE
	TRANSFORMER
	LINKED FUSE (15A, TYPE K)
	LOAD BREAK UNIT
	STREET LIGHTS
	LV POLE
	MV POLE
	KIOSK
	FLY STAY STRUCTURE
	STAY ASSEMBLY FOR 11kV LINE
	STRUT ASSEMBLY FOR 11kV LINE
	STAY ASSEMBLY FOR ABC LINE WITH WARNING PIPE
	STRUT ASSEMBLY FOR ABC LINE
	SLEEVES
	8m KICK POLE FOR AIRGAC
	5m KICK POLE FOR AIRGAC
	KIOSK
	DISTRIBUTION BOARD TYPE "A" OR "B"
	POLE MOUNTED
	BRICK HOUSE
	SINK HOUSE
	WOOD HOUSE

Client

Namibia Power Corporation (Proprietary) Limited
 P.O. Box 2864, Windhoek - 15 Luther Street Windhoek
 T: +264 61 205 4113 F: +264 61 232 905

USER CLIENT

NORED ELECTRICITY (PTY) Ltd
 P.O. Box 639, Ondangwa Namibia - Main Road Ondangwa
 T: +264 65 282 2100 F: +264 65 282 2145

USER CLIENT APPROVAL

APPROVAL PERSONEL: _____ APPROVAL DATE: ____/____/2019

Project
RURAL ELECTRIFICATION OPAWA, PANDULENI AND OTAADHIYA- OMUSATI REGION

Revisions

No.	Description	Drawing Title	Date
0	For tender	Otaadhiya Village Keymap and SLD	07/07/21
1	For construction	Otaadhiya Village Keymap and SLD	18/06/20
2	For As Built	Otaadhiya Village Keymap and SLD	18/03/22


Electrical & Mechanical Engineers

EMCON (Proprietary) Limited - Reg No. 2012/0929
 P.O. Box 1900, Windhoek - 4 Basingsweg 58, Main Windhoek
 T: +264 61 224 725 F: +264 88 651 6173 contact@emcongroup.com

Drawing title
OTAADHIYA VILLAGE KEYMAP AND SINGLE LINE DIAGRAM

Project number: PP239B	Scale N.T.S	Drawing number: NPWR 21/2020-007
	Revision 2	

Designed by: MGA Drawn by: MGA Checked by: HH

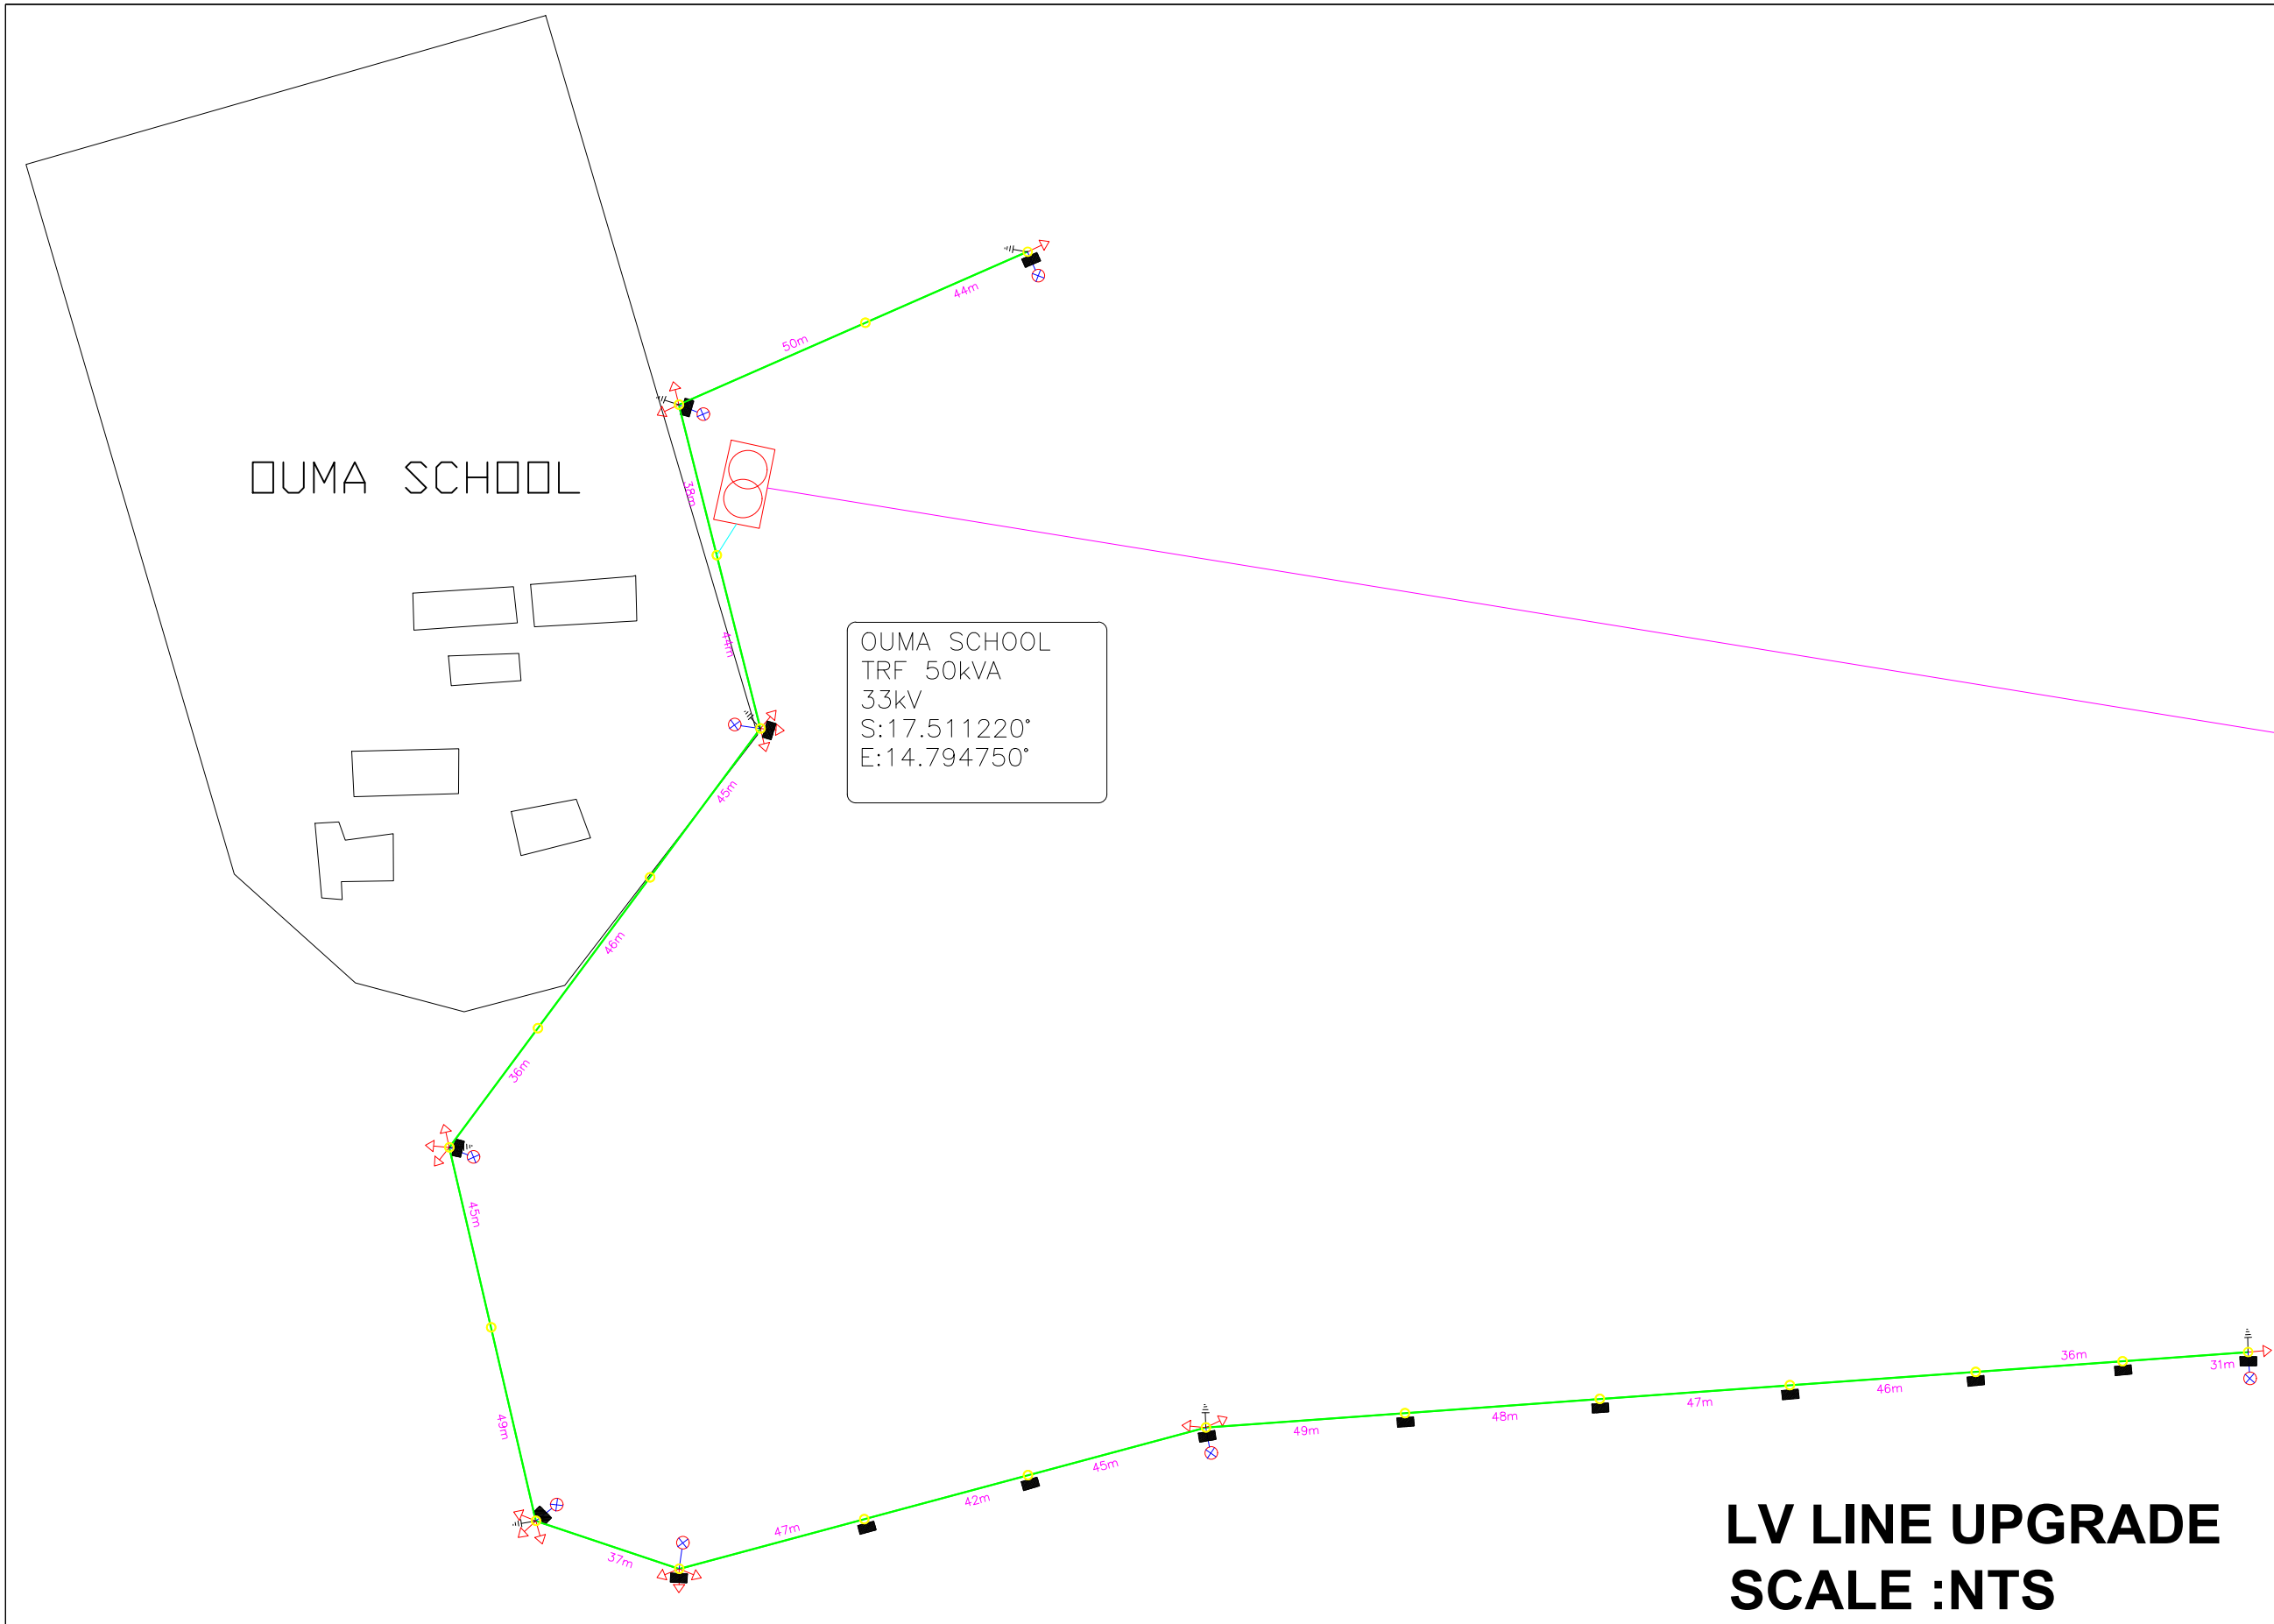



LV LINE UPGRADE SCALE :NTS

NOTES:


LEGEND	
SYMBOL	DESCRIPTION
	DROP OUT FUSE
	LOAD BREAK/SOLID LINKS
	MV POLE (11m&13m)
	MV STAY POLE ASSEMBLY
	POLE MOUNTED METER BOARD
	33 kV MV OH LINE
	TRANSFORMER
	OVERHEAD ABC 400V LINE
	RAILWAY TRACKS
	POLLYBOX
	STAY WITH WARNING PIPE
	STREETLIGHT
	POLE EARTHING
	LV POLE (9m)

ELECTRICAL CONSTRUCTOR
FARADAY'S ELECTRICAL & MECHANICAL
 P O Box 22019, Windhoek
 Tel: (061)221 999
 Fax: (061)247 456



CLIENT

 Namibia Power Corporation (NAMPOWER)
 PO Box 2894
 WINDHOEK
 NAMIBIA
 TEL: +264 61 205 2206
 FAX: +264 61 205 2397

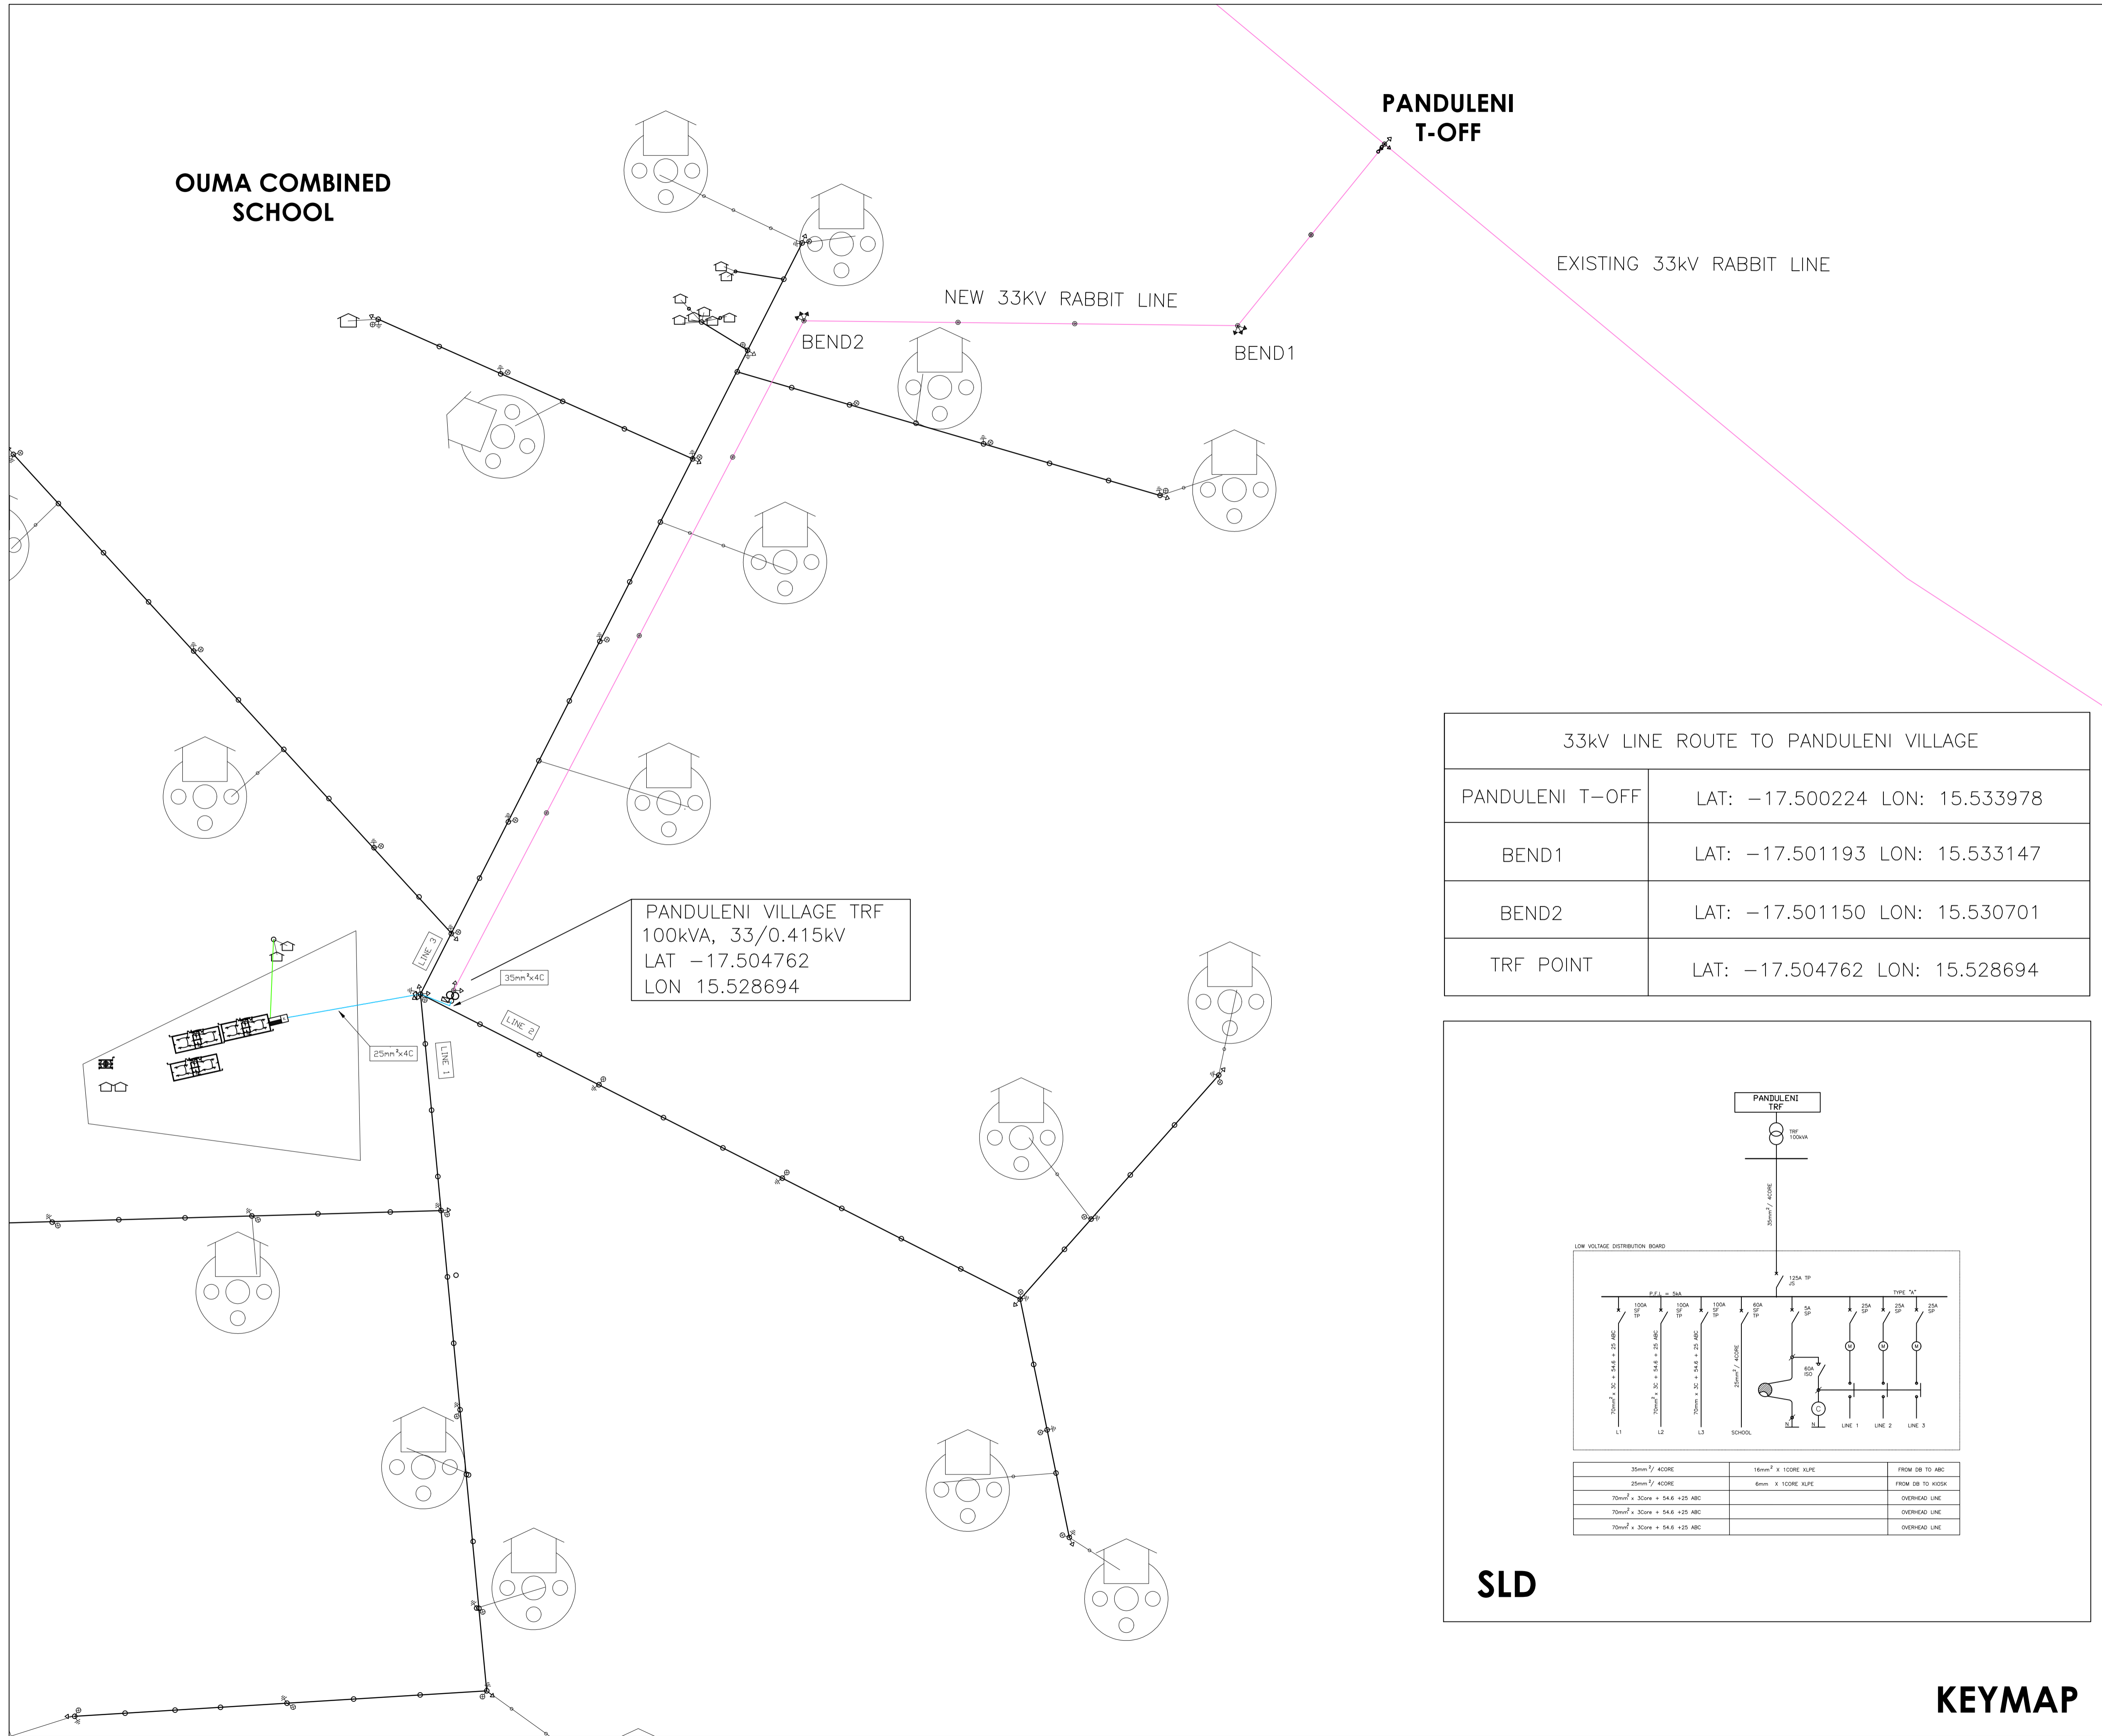PROJECT TITLE		
EXTENSION OF LOW VOLTAGE LINE AT OUMA CUCASHOPS		
DRAWING TITLE		
LOW VOLTAGE LAYOUT		
SCALE	DATE	
	JANUARY 2023	
DRAWN	CHECKED	
LS		
PROJECT NO.		
NPC CODE		
PROJECT NO.	DWG NO.	REVISION FOR APPROVAL




COPYRIGHT:
 COPYRIGHT © 2019 EMCON PSE CONSULTANTS
 ALL RIGHTS RESERVED. NO PART OF THIS DRAWING MAY BE REPRODUCED STORED IN A RETRIEVAL SYSTEM OR TRANSMITTED IN ANY FORM OR BY ANY MEANS ELECTRONIC, ELECTROSTATIC, MAGNETIC TAPE, MECHANICAL, PHOTOCOPYING, RECORDING OR OTHERWISE, WITHOUT THE WRITTEN PERMISSION OF EMCON.

Legend:


	33kV LINE
	22kV LINE
	19.1kV SBER LINE
	11kV OVERHEAD LINE
	11kV LINE UNDERGROUND
	400V ABC LINE
	OVERHEAD SERVICE CABLE
	UNDERGROUND SERVICE CABLE
	TELEPHONE LINE
	TRANSFORMER
	LINKED FUSE (15A, TYPE K)
	LOAD BREAK UNIT
	STREET LIGHTS
	LV POLE
	MV POLE
	KIOSK
	FLY STAY STRUCTURE
	STAY ASSEMBLY FOR 11kV LINE
	STRUT ASSEMBLY FOR 11kV LINE
	STAY ASSEMBLY FOR ABC LINE WITH WARNING PIPE
	STRUT ASSEMBLY FOR ABC LINE
	SLEEVES
	8m KICK POLE FOR AIRGAC
	5m KICK POLE FOR AIRGAC
	KIOSK
	DISTRIBUTION BOARD TYPE "A" OR "B"
	POLE MOUNTED
	BRICK HOUSE
	SINK HOUSE
	WOOD HOUSE

33kV LINE ROUTE TO PANDULENI VILLAGE	
PANDULENI T-OFF	LAT: -17.500224 LON: 15.533978
BEND1	LAT: -17.501193 LON: 15.533147
BEND2	LAT: -17.501150 LON: 15.530701
TRF POINT	LAT: -17.504762 LON: 15.528694

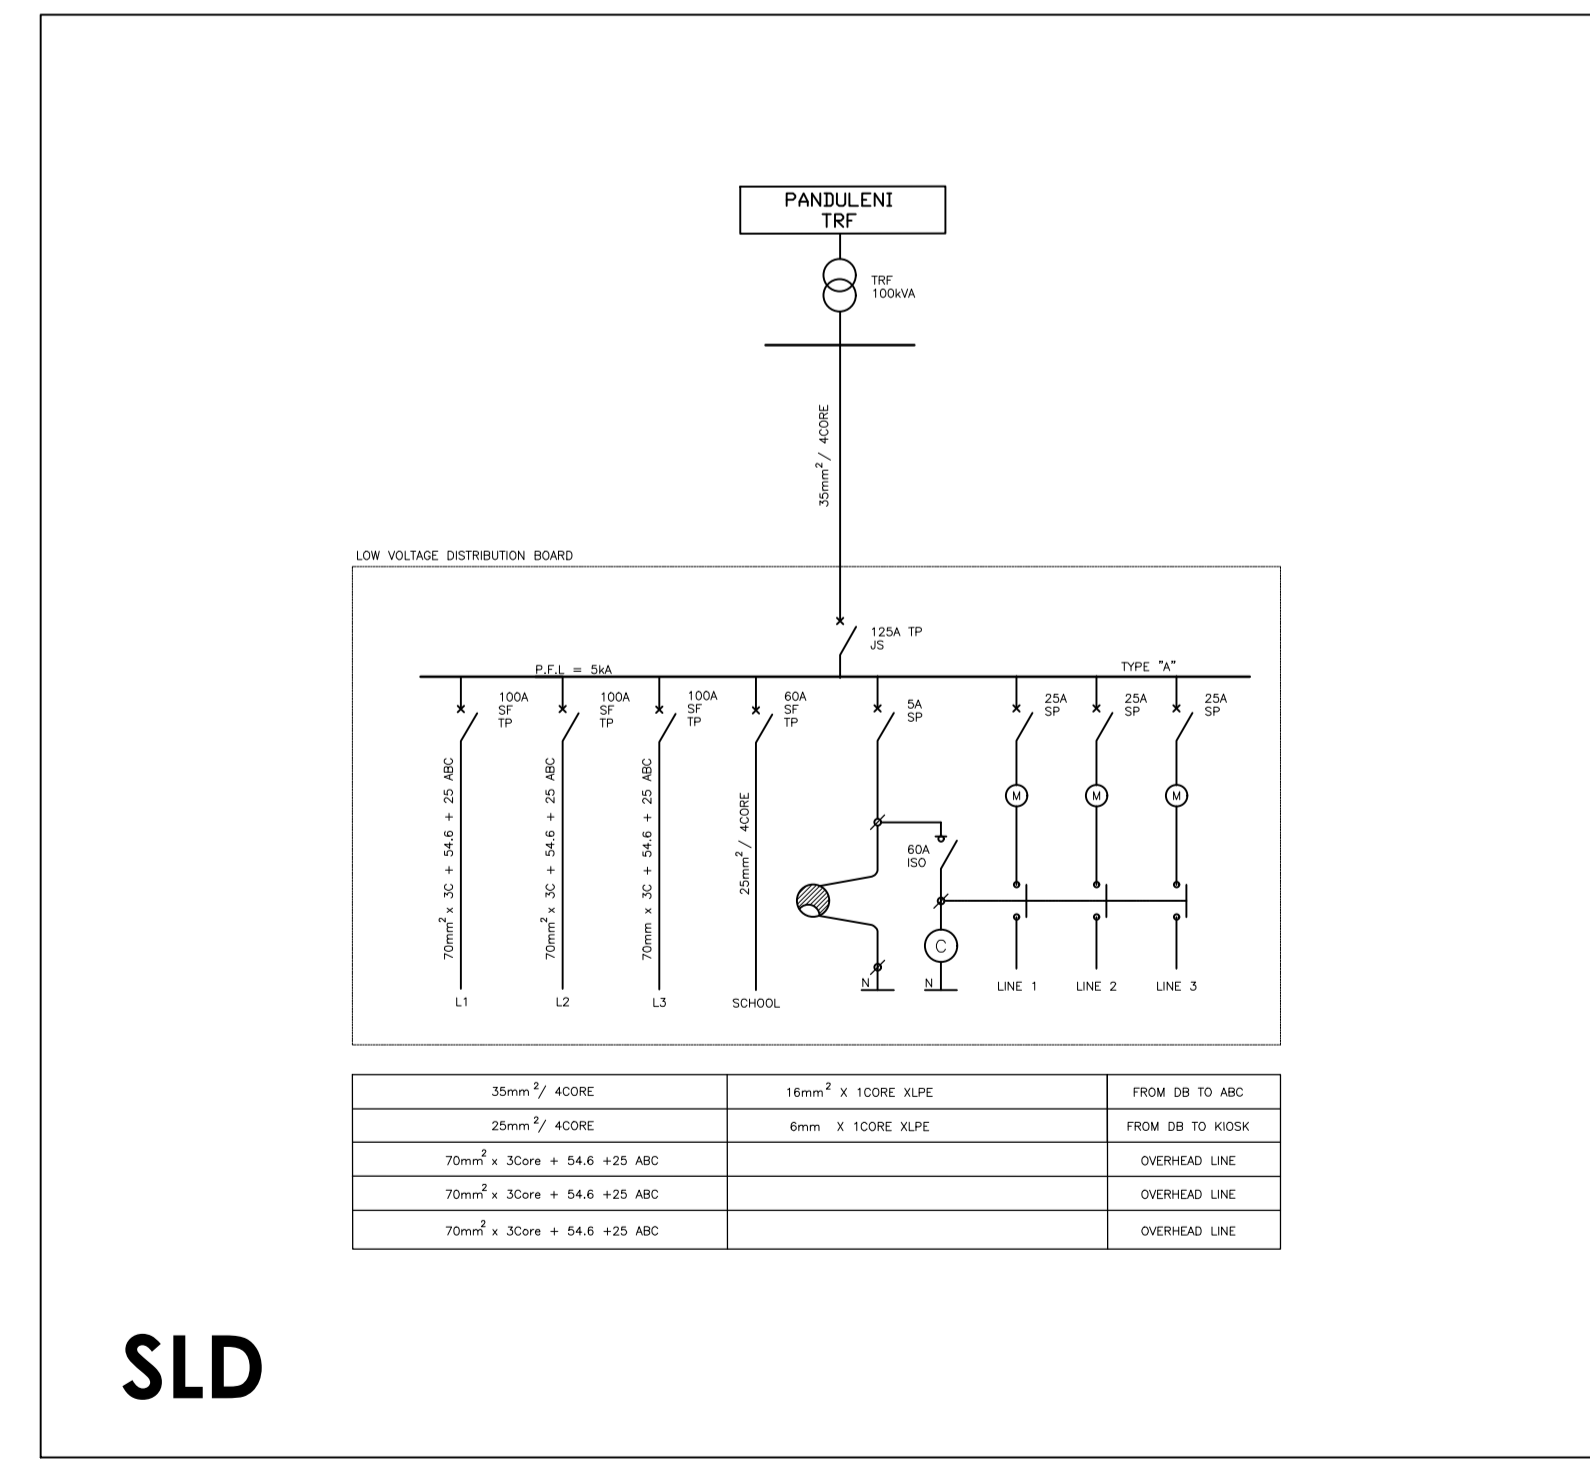

SLD

KEYMAP

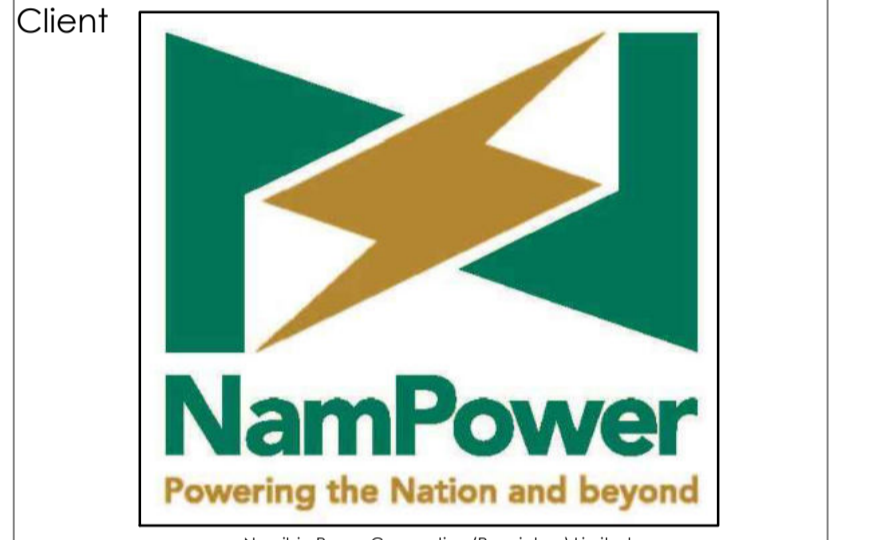

Namibia Power Corporation (Proprietary) Limited
 P.O. Box 2864, Windhoek - 15 Luther Street Windhoek
 T: +264 61 205 4111 F: +264 61 232 955



NORED ELECTRICITY (PTY) Ltd
 P.O. Box 639, Ondangwa Namibia - Main Road Ondangwa
 T: +264 65 282 2100 F: +264 65 282 2145

USER CLIENT APPROVAL

APPROVAL PERSONEL: _____ APPROVAL DATE: ____/____/2019

Project
 RURAL ELECTRIFICATION OPAWA, PANDULENI AND OTAADHIYA- OMUSATI REGION

Revisions

No.	Description	Drawing Title	Date
0	For tender	Panduleni Village Keymap and SLD	07/07/21
1	For construction	Panduleni Village Keymap and SLD	18/06/20
2	For As Built	Panduleni Village Keymap and SLD	18/03/22



EMCON (Proprietary) Limited - Reg No. 2012/0929
 P.O. Box 1900, Windhoek - 4 Basingsweg 58, Klein Windhoek
 T: +264 61 224 725 F: +264 88 651 6173 contact@emcongroup.com

Drawing title
 PANDULENI VILLAGE KEYMAP AND SINGLE LINE DIAGRAM

Project number:	Scale	Drawing number:
PP239B	N.T.S	NPWR 21/2020-004
	Revision	
	2	

Designed by: MGA Drawn by: MGA Checked by: HH