


ALL DRAWINGS & DIMENSIONS MUST BE CORRELATED BEFORE:  
 - ANY MATERIALS ARE ORDERED  
 - ANY CONSTRUCTION WORK COMMENCES  
 ANY DISCREPANCIES MUST BE BROUGHT UNDER OUR IMMEDIATE ATTENTION.  
 COPY RIGHT IS RESERVED ON ALL DRAWINGS ISSUED.

NOTES:

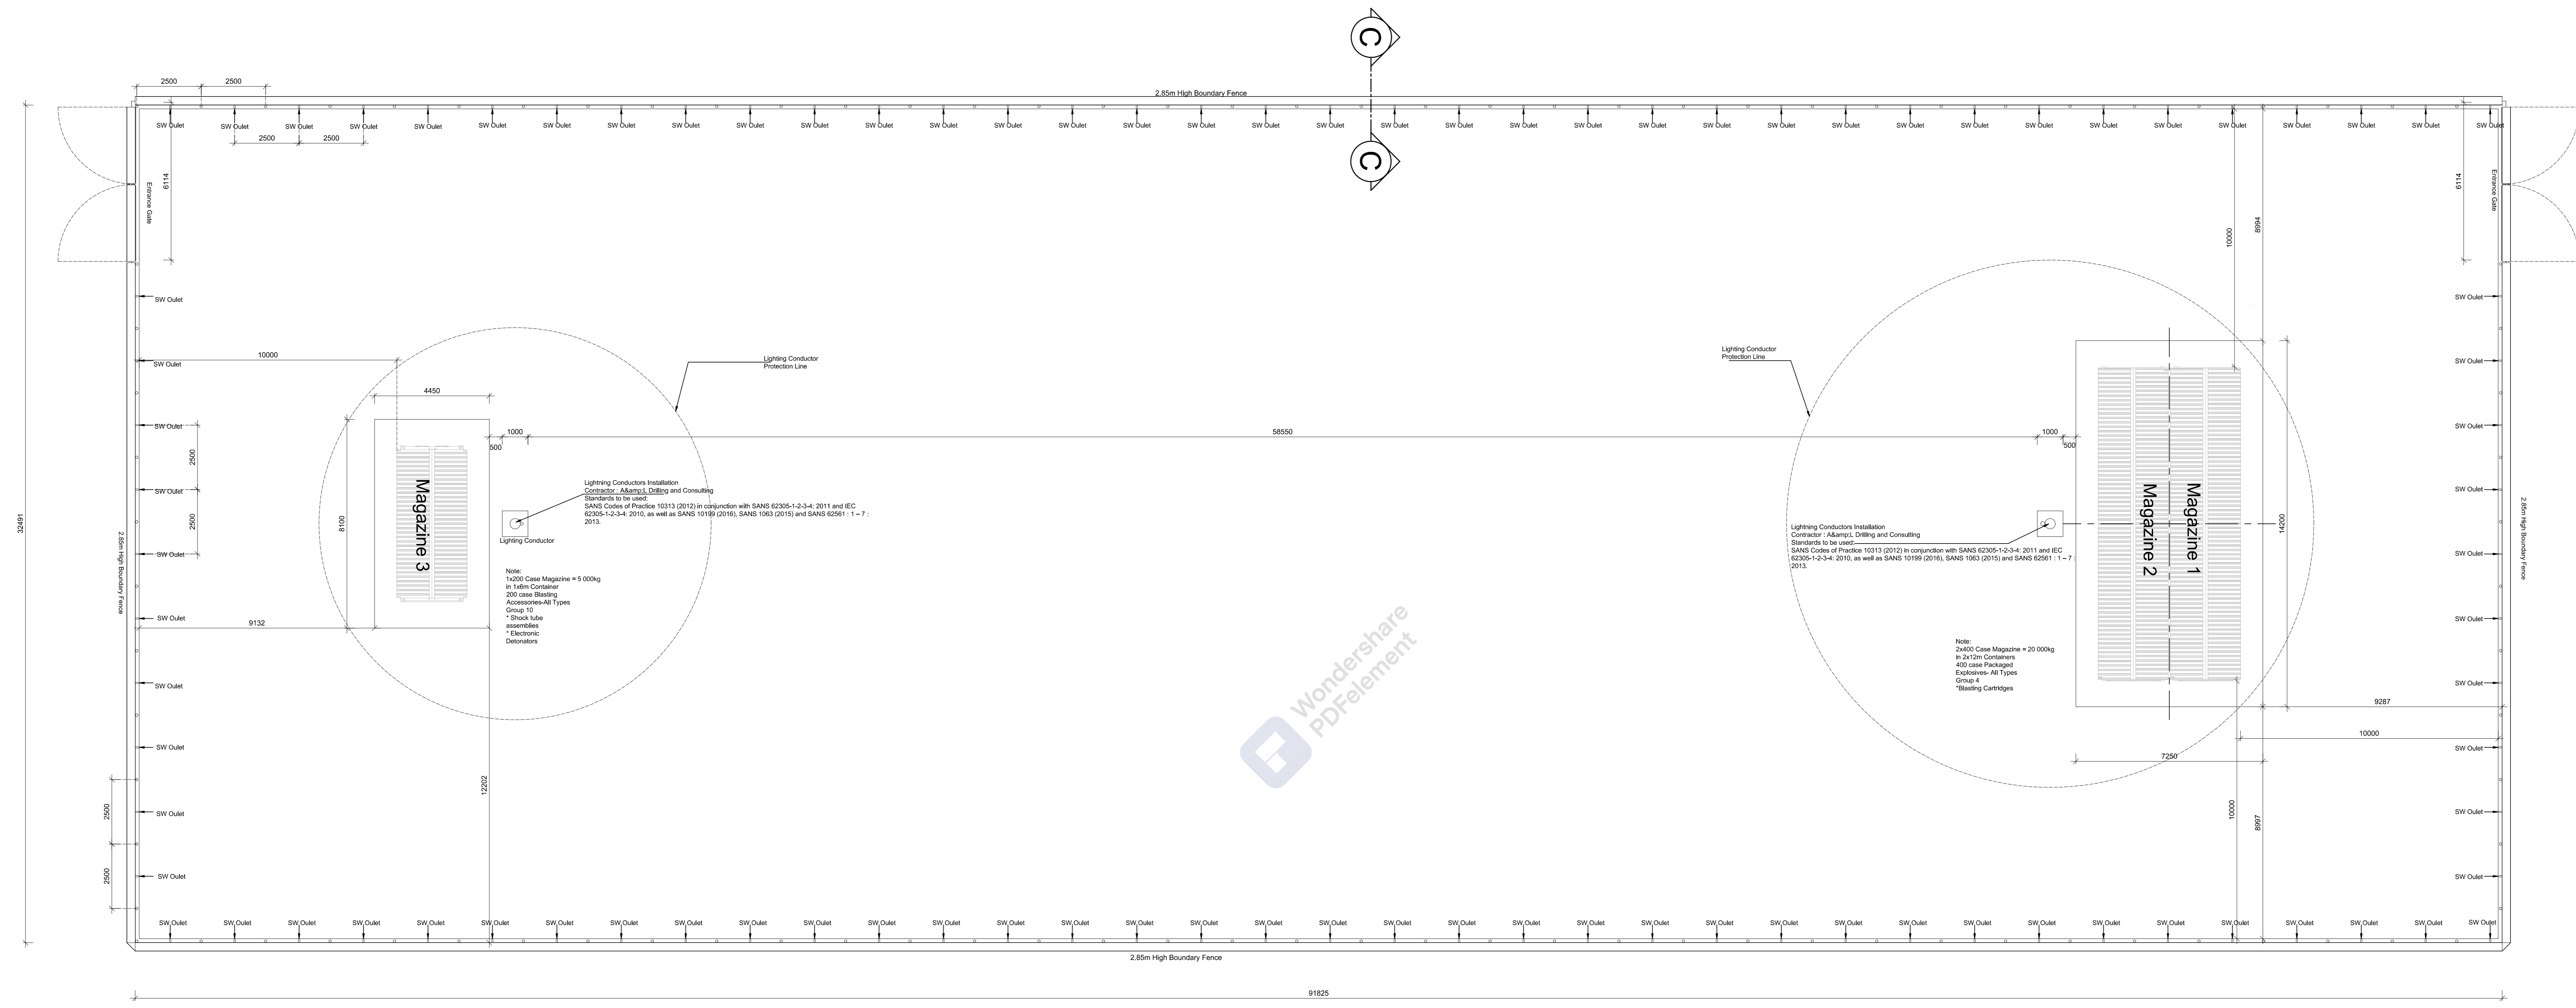

Lightning Conductor Installation Contractor (Alarm), Drilling and Consulting Standards to be used: SANS Code of Practice 10113 (2012) in conjunction with SANS 62055-1-2-3-4: 2011 and IEC 62056-1-2-3-4: 2010, as well as SANS 10189 (2016), SANS 1063 (2015) and SANS 62661: 1 - 7: 2013.

Note:  
 1x300 Case Magazine = 3 000kg  
 in 1x6m Container  
 200 case Blasting Accessories-All Types  
 Group 1.5  
 \* Shock tube assemblies  
 \* Electronic Detonators

Lightning Conductor Installation Contractor (Alarm), Drilling and Consulting Standards to be used: SANS Code of Practice 10113 (2012) in conjunction with SANS 62055-1-2-3-4: 2011 and IEC 62056-1-2-3-4: 2010, as well as SANS 10189 (2016), SANS 1063 (2015) and SANS 62661: 1 - 7: 2013.

Note:  
 2x400 Case Magazine = 20 000kg  
 in 2x12m Containers  
 400 case Blasting Accessories-All Types  
 Group 1.5  
 \* Blasting Cartridges

Site Plan Layout Magazine 1-3 Scale 1:100

Note:  
 All Measurements are in mm

Service Provider:

**B**  
**BAREND LIEBERBERG**  
 -ARCHITECTURAL DESIGN-  
 Tel: 081 374 4475 Po Box: 11077 Klein Windhoek  
 Email: lieberberg54@gmail.com

Client: **AL Drilling & Blasting**  
 P.O. Box: Tel: 081 274 2295

Project Title:  
 New Magazine at NAMDEB  
 Oranjemund Namibia

Drawing Title:  
**Municipal Approval**

- Site Plan Layout

Job Number: **Magazine 1** Date: 12/7/2022  
 Drawn: B.C.L.  
 Checked: B.C.L.